


This document and the design it covers are the property of PARSONS. They are loaned only with the borrower's expressed written agreement that they will not be reproduced, copied, loaned, exhibited, or used in any other way, except by written consent from PARSONS to the borrower.

This document and the design it covers are the property of PARSONS. They are loaned only with the borrower's expressed written agreement that they will not be reproduced, copied, loaned, exhibited, or used in any other way, except by written consent from PARSONS to the borrower.

FOR JUI BY USE: 780 1170 551580C DEVELUTSURELES\1862\WML\PLT

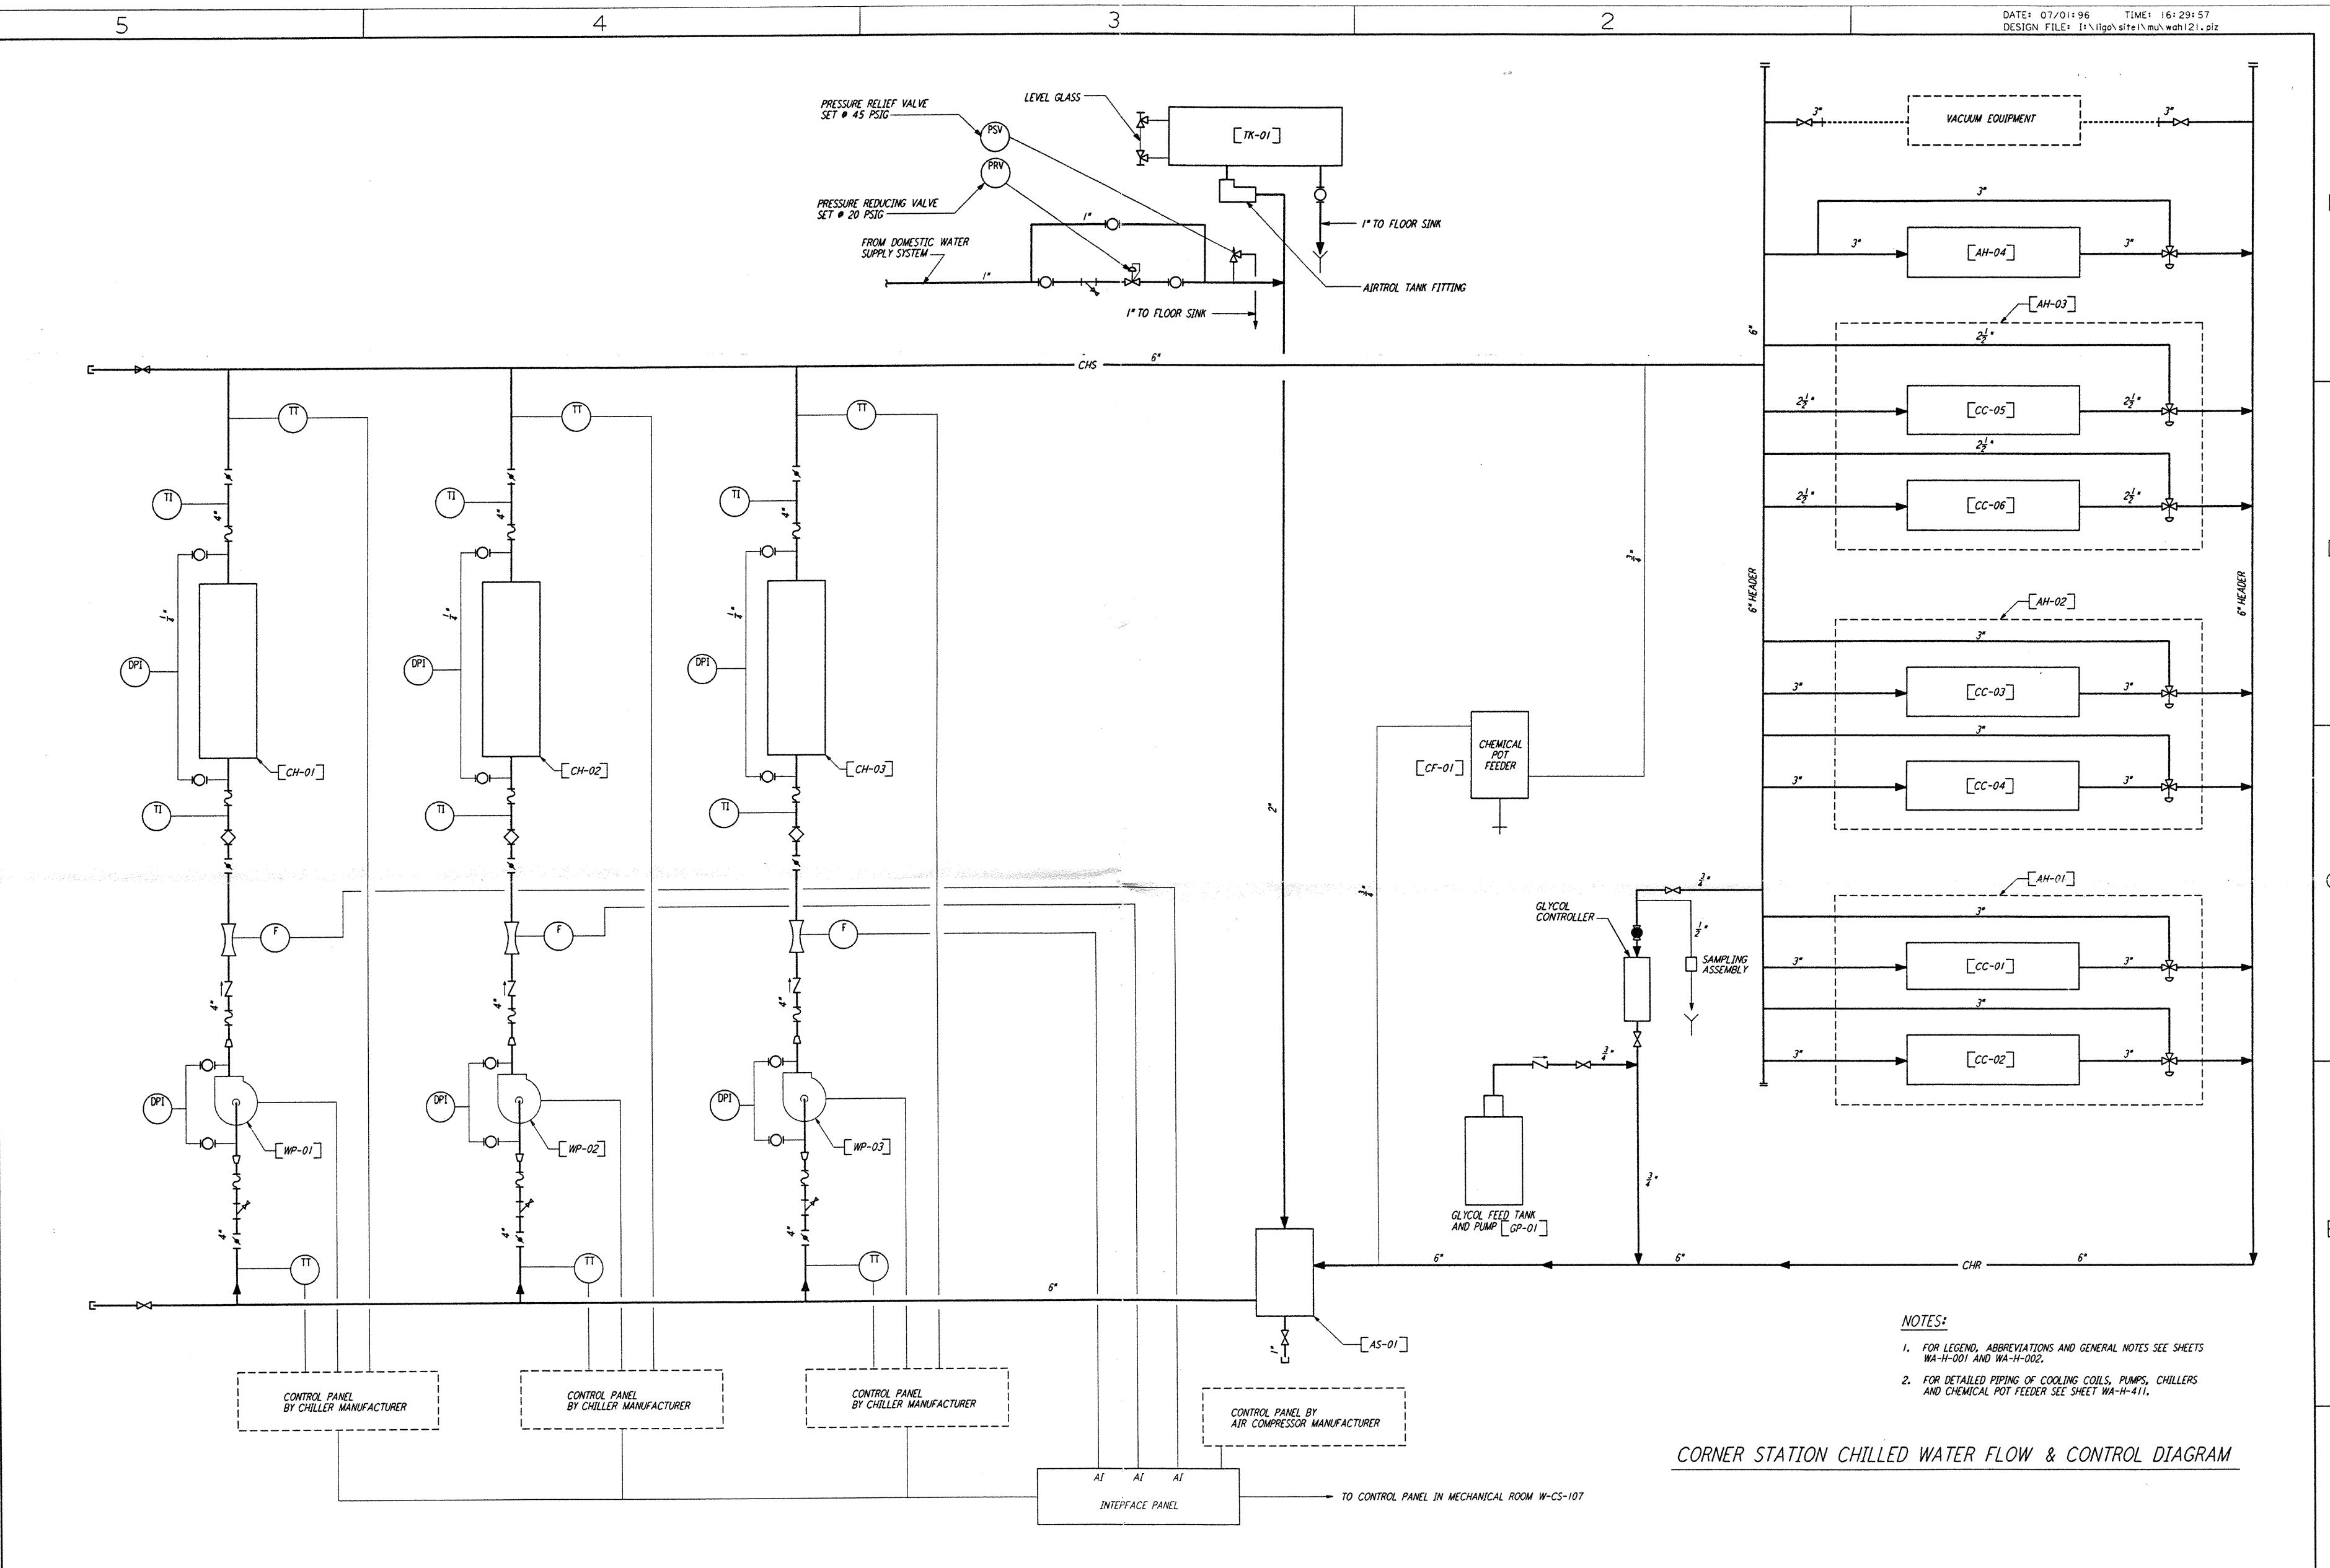


- NOTES:**
- FOR LEGEND, ABBREVIATIONS AND GENERAL NOTES SEE SHEETS WA-H-001 AND WA-H-002.
  - FOR DETAILED PIPING OF COOLING COILS, PUMPS, CHILLERS AND CHEMICAL POT FEEDER SEE SHEET WA-H-411.

**CORNER STATION CHILLED WATER FLOW & CONTROL DIAGRAM**

DRAWING NO.	DESCRIPTION	NO.	DATE	BY	CHKD	ENGR	PROJ	DESCRIPTION

ISSUED FOR CONSTRUCTION	
DRAWN	CLP 6-24-96
CHECKED	7/13/96
ENGINEER	AA 7/13/96
PROJ	1166W 7/18/96

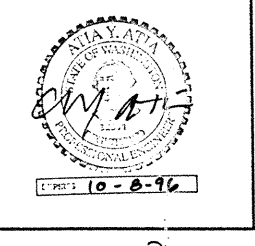

**PARSONS**  
 100 WEST WALNUT STREET  
 PASADENA, CALIFORNIA

**LIGO**  
 CALIFORNIA INSTITUTE OF TECHNOLOGY  
 MASSACHUSETTS INSTITUTE OF TECHNOLOGY

LASER INTERFEROMETER  
 GRAVITATIONAL-WAVE OBSERVATORY  
 SITE NO. 1 - HANFORD, WASHINGTON

TITLE	HVAC CORNER STATION CHILLED WATER FLOW DIAGRAM	SCALE	NONE	CONTRACT NUMBER	PP150969	PROJECT NUMBER	8094
SHEET NUMBER	WA-H-121	REVISION					

LIGO-D960354-00-0

LIGOWAF.BDR