


This document and the design it covers are the property of PARSONS. They are loaned only with the borrower's expressed written agreement that they will not be reproduced, copied, loaned, exhibited, or used in any other way, except by written consent from PARSONS to the borrower.

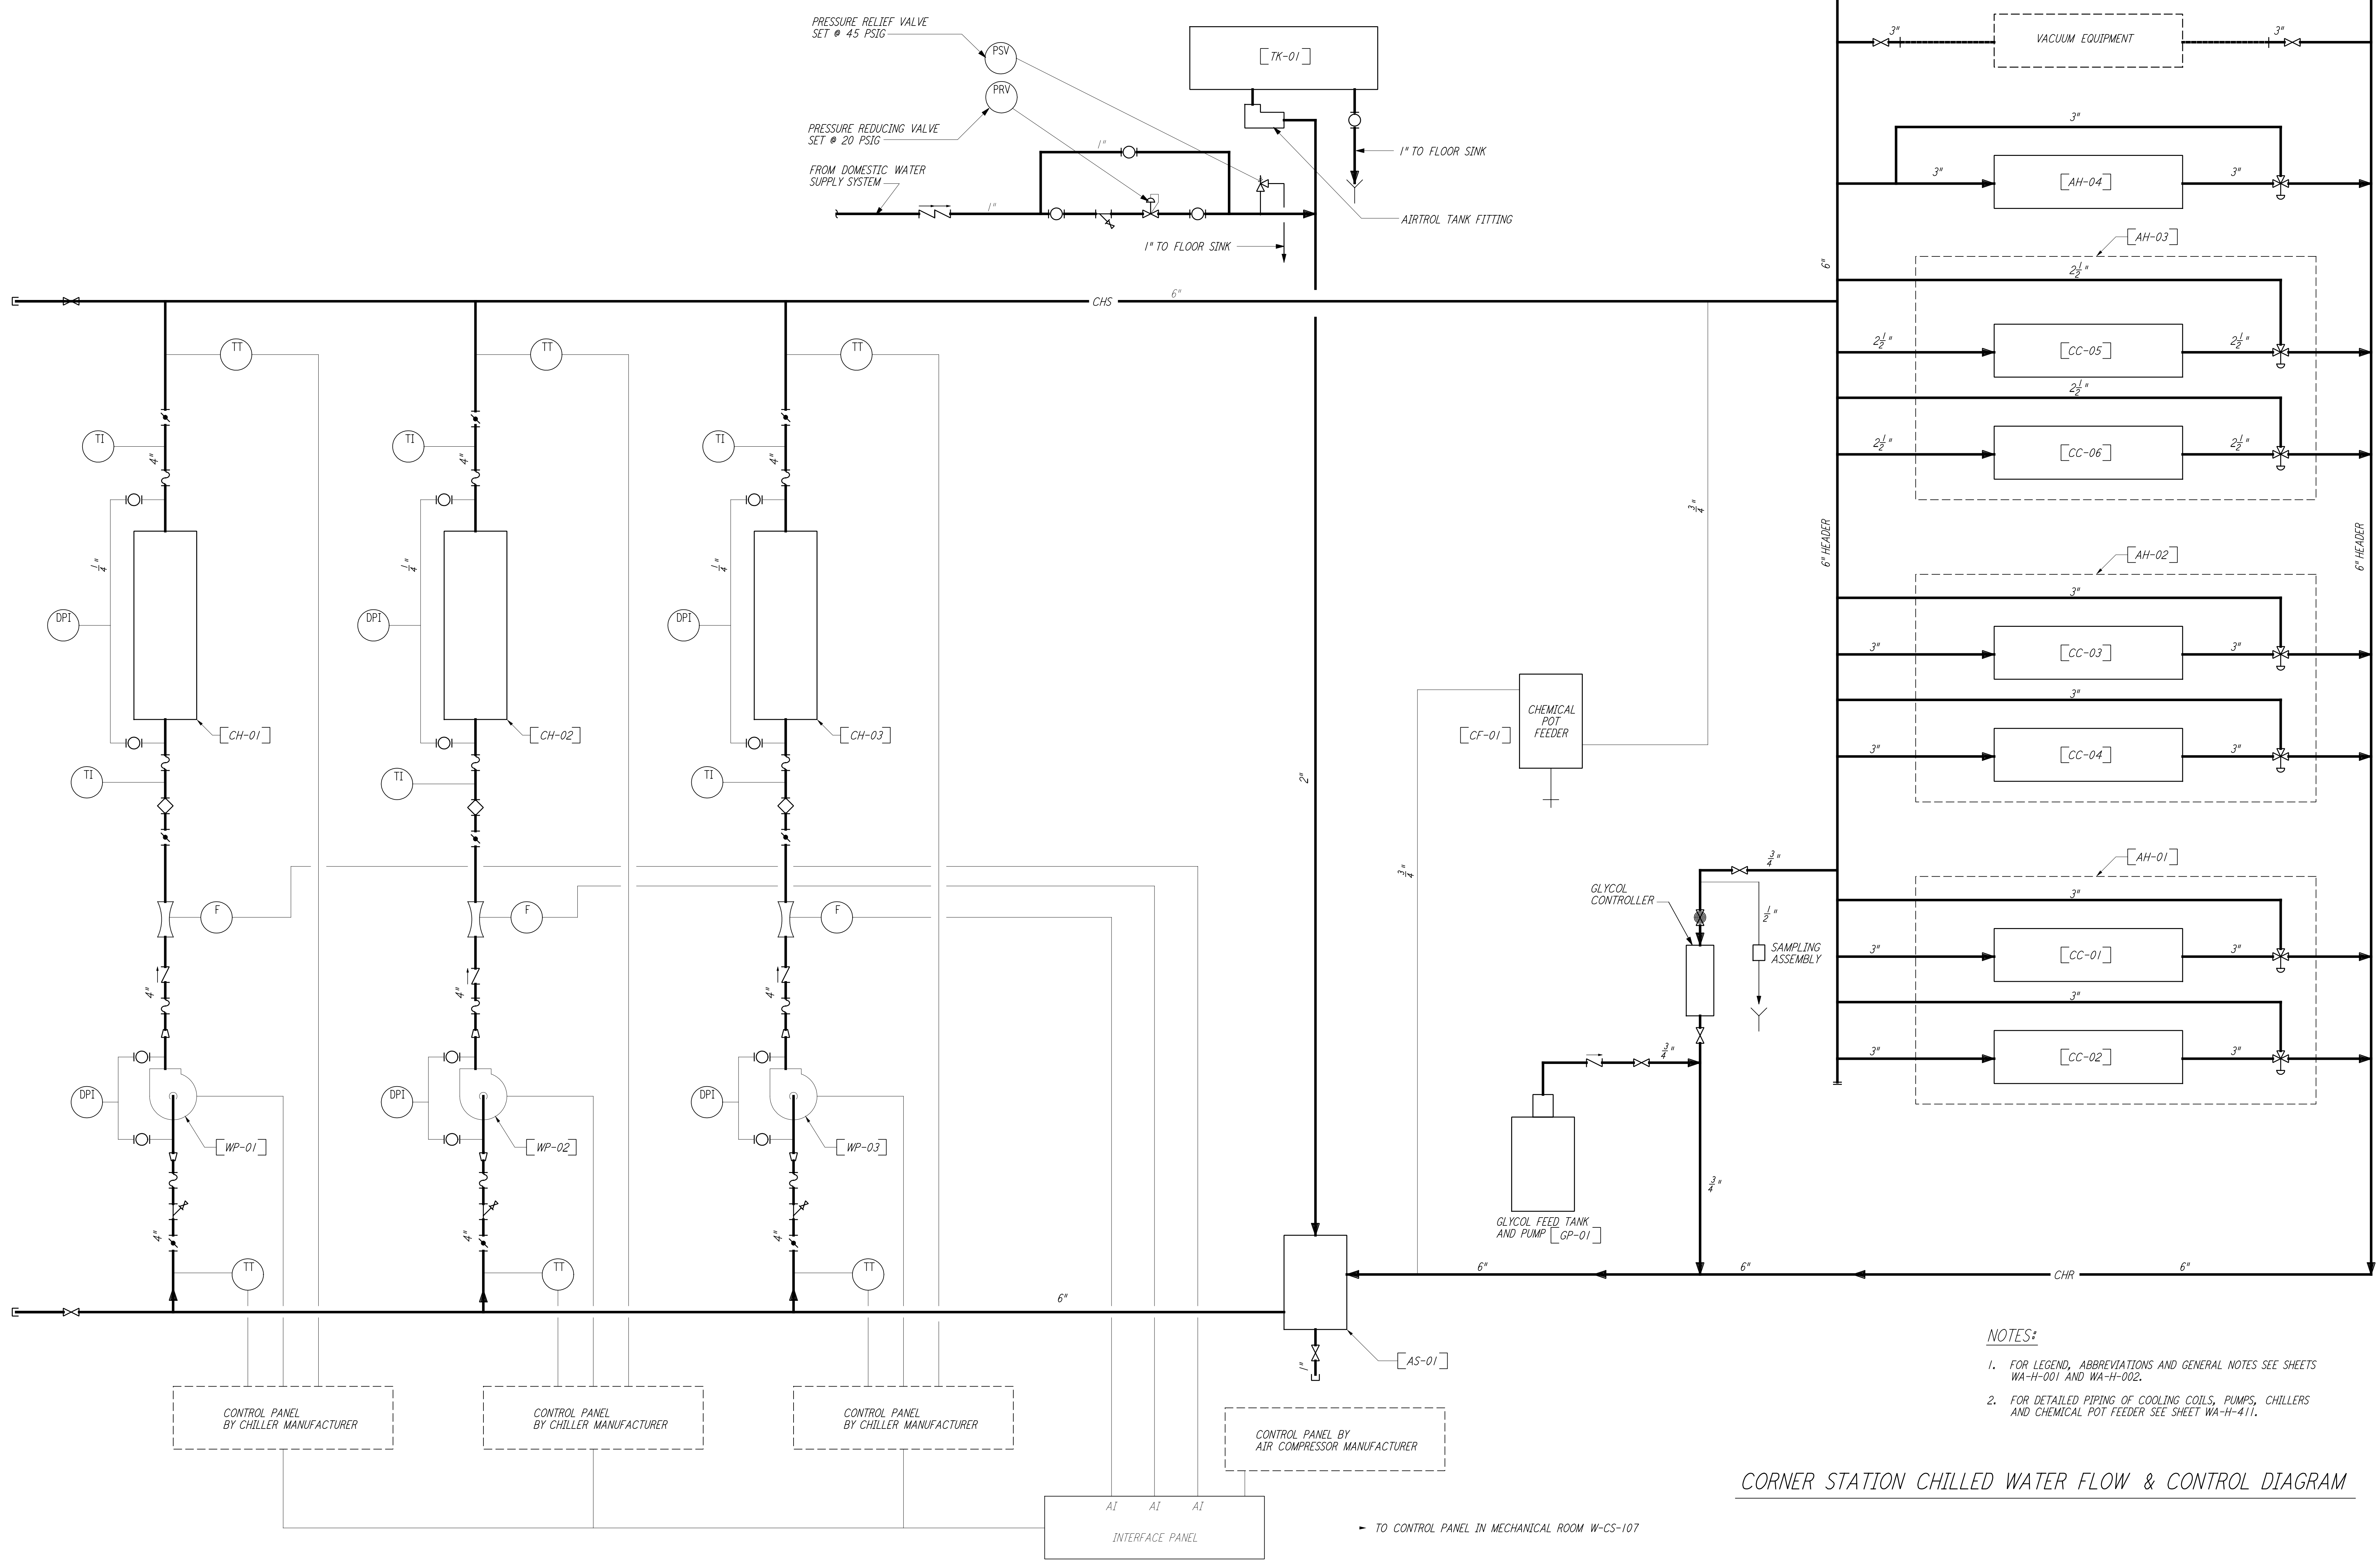

- NOTES:**
- FOR LEGEND, ABBREVIATIONS AND GENERAL NOTES SEE SHEETS WA-H-001 AND WA-H-002.
 - FOR DETAILED PIPING OF COOLING COILS, PUMPS, CHILLERS AND CHEMICAL POT FEEDER SEE SHEET WA-H-411.

CORNER STATION CHILLED WATER FLOW & CONTROL DIAGRAM

NO.	DATE	BY	CHKD	ENGR	PROJ	DESCRIPTION
1	5-15-98	CP				ISSUED FOR AS-BUILT

ISSUED FOR CONSTRUCTION
 DRAWN CLP 6-24-96
 CHECKED
 ENGINEER
 PROJ
AS-BUILT DRAWINGS



LIGO-D960354-01-O
 LASER INTERFEROMETER GRAVITATIONAL-WAVE OBSERVATORY
 SITE NO. 1 - HANFORD, WASHINGTON
 TITLE HVAC CORNER STATION CHILLED WATER FLOW DIAGRAM
 SCALE NONE SHEET NUMBER PPI50969 PROJECT NUMBER 8094
WA-H-121