


This document and the design it covers are the property of PARSONS. They are loaned only with the borrower's expressed written agreement that they will not be reproduced, copied, loaned, exhibited, or used in any other way, except by written consent from PARSONS to the borrower.

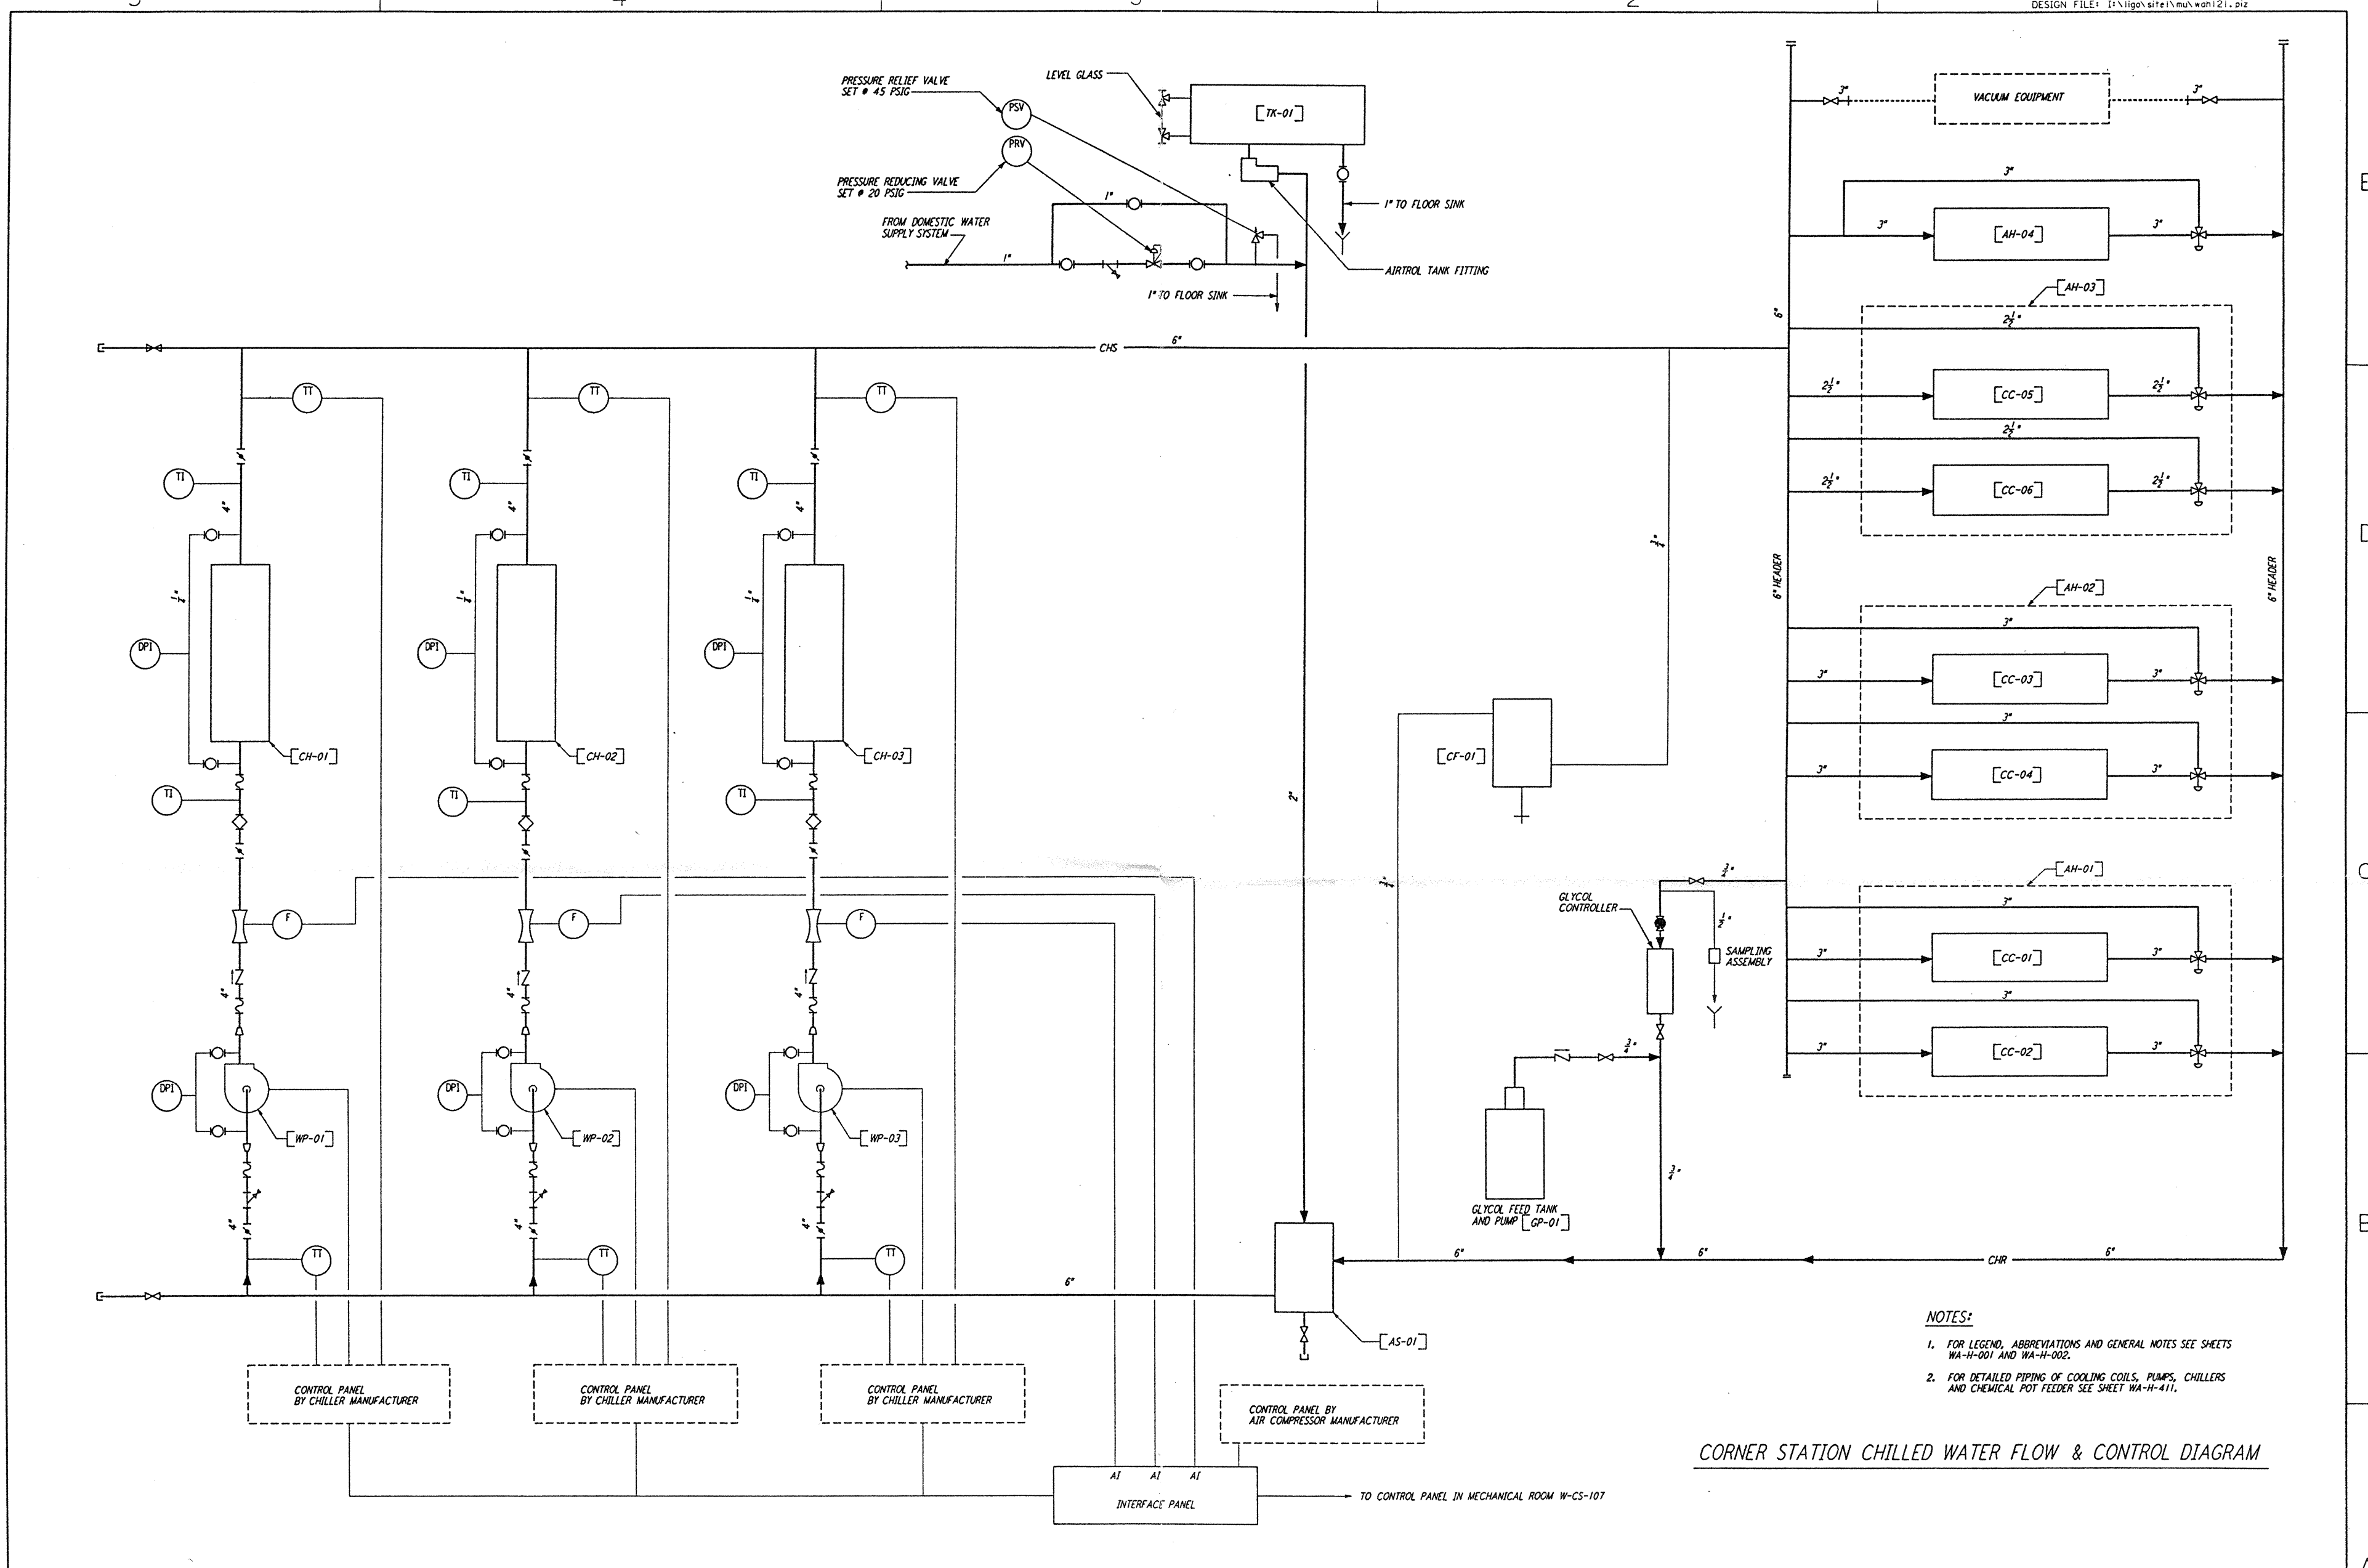

- NOTES:**
- FOR LEGEND, ABBREVIATIONS AND GENERAL NOTES SEE SHEETS WA-H-001 AND WA-H-002.
 - FOR DETAILED PIPING OF COOLING COILS, PUMPS, CHILLERS AND CHEMICAL POT FEEDER SEE SHEET WA-H-411.

CORNER STATION CHILLED WATER FLOW & CONTROL DIAGRAM

NO.	DATE	BY	CHKD	ENGR	PROJ	DESCRIPTION
B	4-19-96	CLP	ME	AA	TDM	FINAL DESIGN REVIEW & BID
A	10-31-95	CLP	ME	AA	TDM	PRELIMINARY DESIGN REVIEW

DRAWN	CLP
CHECKED	
ENGINEER	
PROJ	

PARSONS
 100 WEST WALNUT STREET
 PASADENA, CALIFORNIA

LIGO
 CALIFORNIA INSTITUTE OF TECHNOLOGY
 MASSACHUSETTS INSTITUTE OF TECHNOLOGY

LASER INTERFEROMETER GRAVITATIONAL-WAVE OBSERVATORY SITE NO. 1 - HANFORD, WASHINGTON	
TITLE HVAC CORNER STATION CHILLED WATER FLOW DIAGRAM	SCALE NONE
CONTRACT NUMBER PP150969	PROJECT NUMBER 8094
SHEET NUMBER WA-H-121	

LIGO-D960354-B+D

100% PLOT: 04/19/96 11:45:00 AM 53-43662-145\PLANS\W0121.DWG