


LVEA CONTROL DIAGRAM

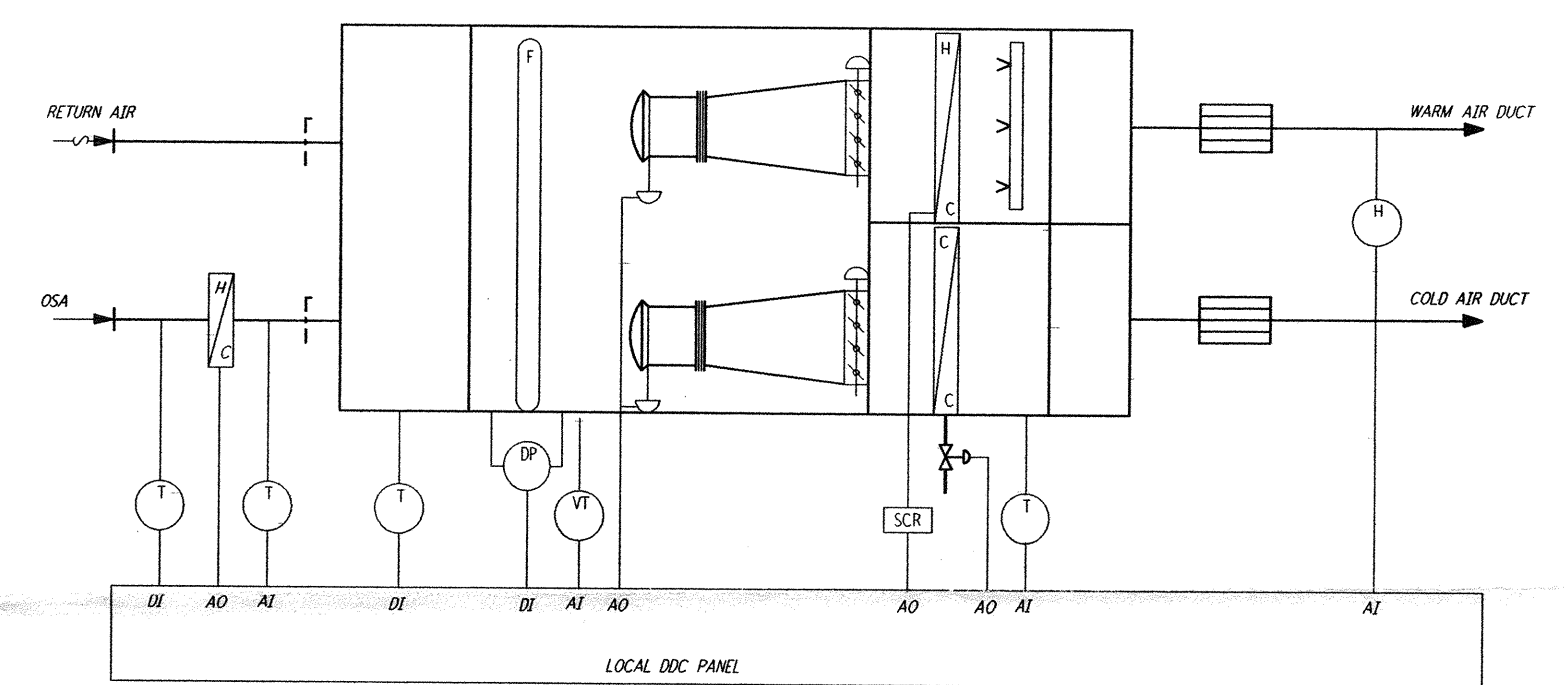

OSB CONTROL DAIGRAM

not be reproduced, copied, loaned, exhibited, or used in any other way, except by written consent from PARSONS to the borrower.

This document and the design it covers are the property of PARSONS. They are loaned only with the borrower's expressed written agreement that they will

REVISION	NO.	DATE	APPR BY	DESCRIPTION OF REVISION
9				
8				
7				
6				
5				
4				
3				
2				
1				

ISSUE	NO.	DATE	APPR BY	ISSUED FOR
J				
H				
G				
F				
E				
D				
C				
B				
A	10/31/95	TDM		PRELIMINARY DESIGN REVIEW

DATE	10/31/95
DRAWN	CLP
CHECKED	
ENGINEER	
PROJ. MGR	

PARSONS
 100 WEST WALNUT STREET
 PASADENA, CALIFORNIA

LIGO
 CALIFORNIA INSTITUTE OF TECHNOLOGY
 MASSACHUSETTS INSTITUTE OF TECHNOLOGY

LASER INTERFEROMETER
 GRAVITATIONAL-WAVE OBSERVATORY
 SITE NO. 1 - HANFORD, WASHINGTON

TITLE	CORNER STATION LVEA AND OSB AIR FLOW AND CONTROL DIAGRAM	SCALE	NONE	CONTRACT NUMBER	PP150969	PROJECT NUMBER	8094
SHEET NUMBER	WA-H-122	REVISIONS					

Mon Oct 30 21:22:10 1995 S3-V18B2 J:\PLOTS\QUEUES\V18B2\MU122C.PRF