 



- NOTES:**
- FOR LEGEND, ABBREVIATIONS AND GENERAL NOTES SEE SHEETS WA-H-001 AND WA-H-002.
 - SEE FLOOR PLAN NOTES FOR DUCT INSULATION.

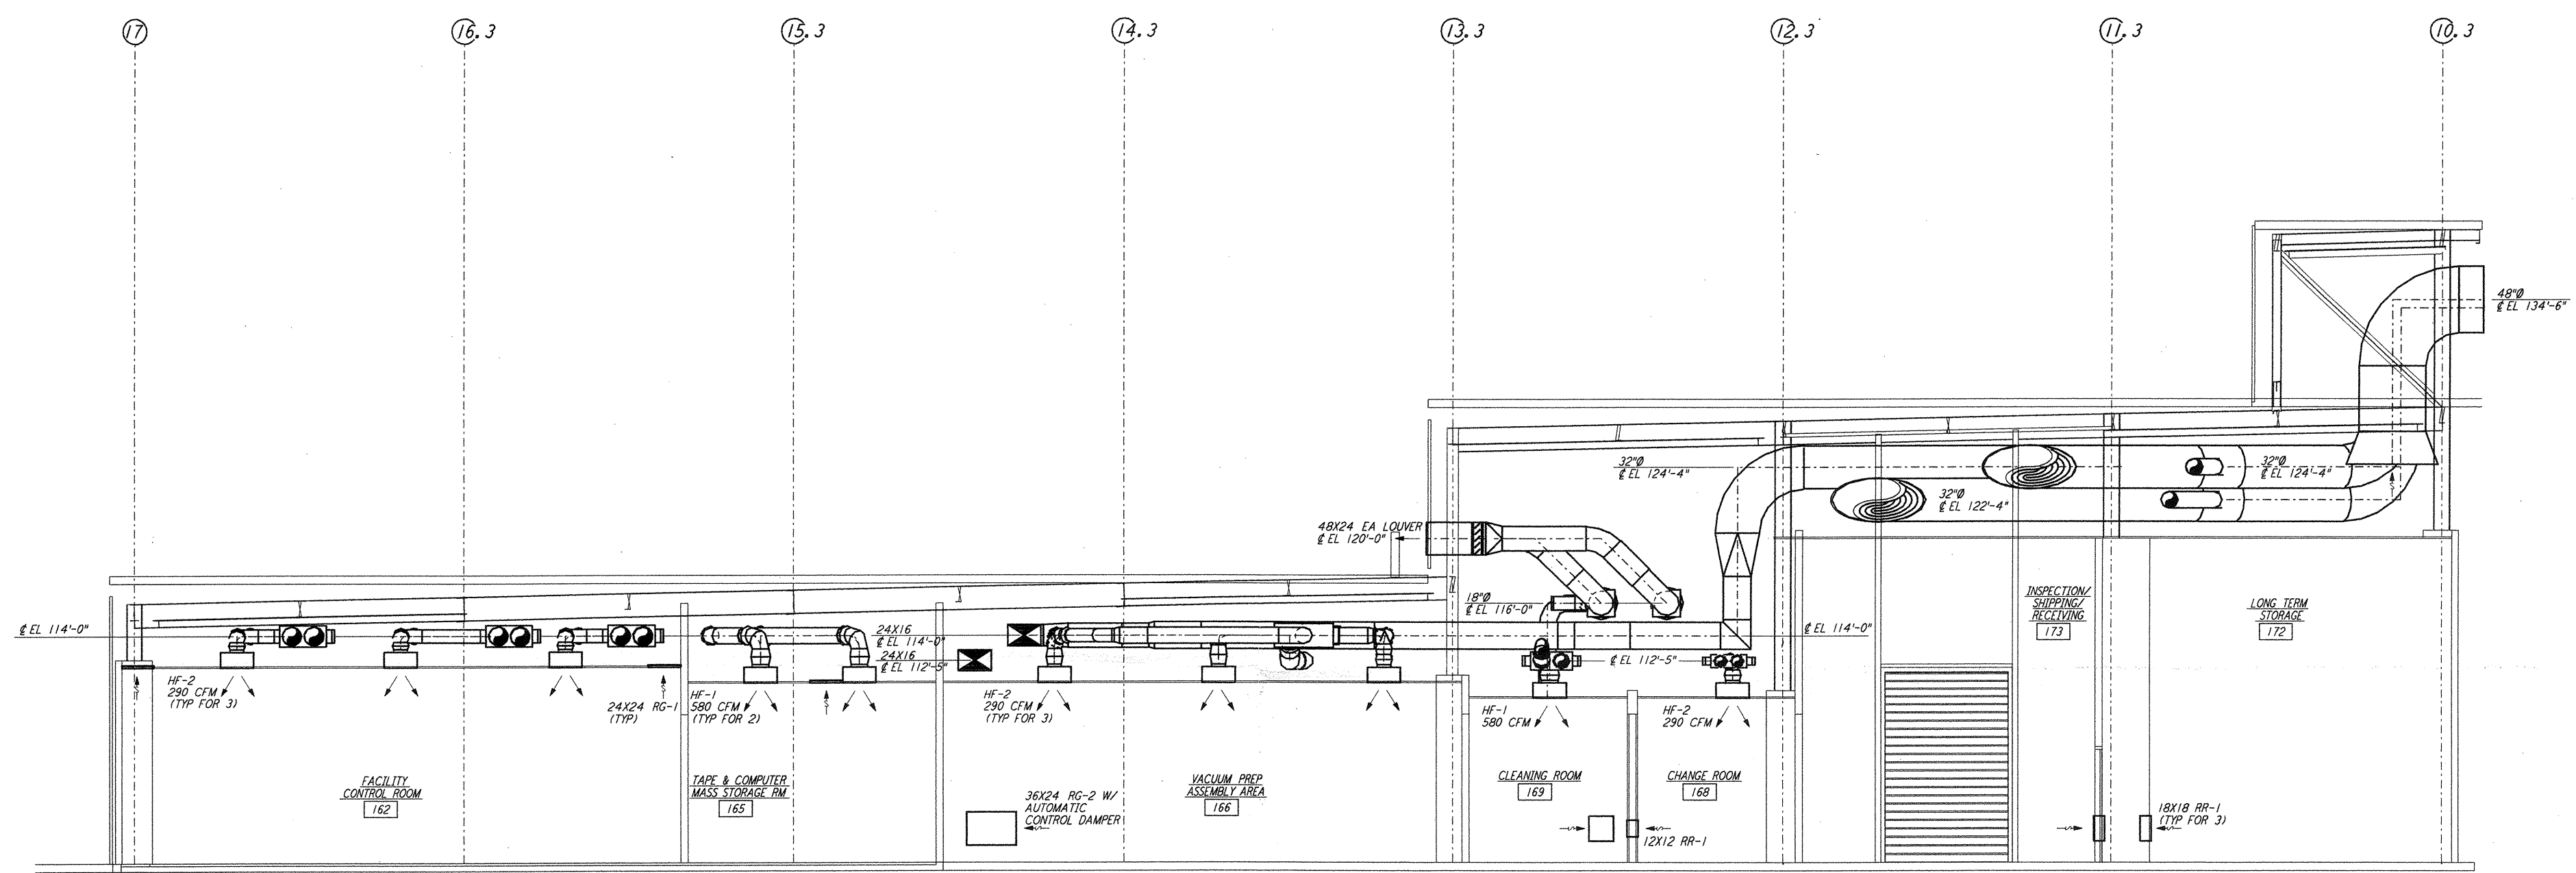

LIGO-D960359-01-0

NO.	DATE	BY	CHKD	ENGR	PROJ	DESCRIPTION
1	5-15-98	CP	AA	AA	PX	ISSUED FOR AS-BUILT

ISSUED FOR CONSTRUCTION			
DRAWN	CLP	6-24-96	
CHECKED	ME	7/2/96	
ENGINEER	AA	7/3/96	
PROJ	MDU	7/7/96	

AS-BUILT DRAWINGS

PARSONS
 100 WEST WALNUT STREET
 PASADENA, CALIFORNIA

LIGO
 CALIFORNIA INSTITUTE OF TECHNOLOGY
 MASSACHUSETTS INSTITUTE OF TECHNOLOGY

LASER INTERFEROMETER GRAVITATIONAL-WAVE OBSERVATORY SITE NO. 1 - HANFORD, WASHINGTON		
TITLE	SCALE	CONTRACT NUMBER
HVAC CORNER STATION SECTIONS SHEET 3	AS NOTED	PP150969
	SHEET NUMBER	PROJECT NUMBER
	WA-H-153	8094

This document and the design it covers are the property of PARSONS. They are loaned only with the borrower's expressed written agreement that they will not be reproduced, copied, loaned, exhibited, or used in any other way, except by written consent from PARSONS to the borrower.

E
D
C
B
A
 L:\ligo\site\lmu\wah153.d3z