



**NOTES:**  
 1. FOR LEGEND, ABBREVIATIONS AND GENERAL NOTES SEE SHEETS WA-H-001 AND WA-H-002.  
 2. SEE FLOOR PLAN NOTES FOR DUCT INSULATION.

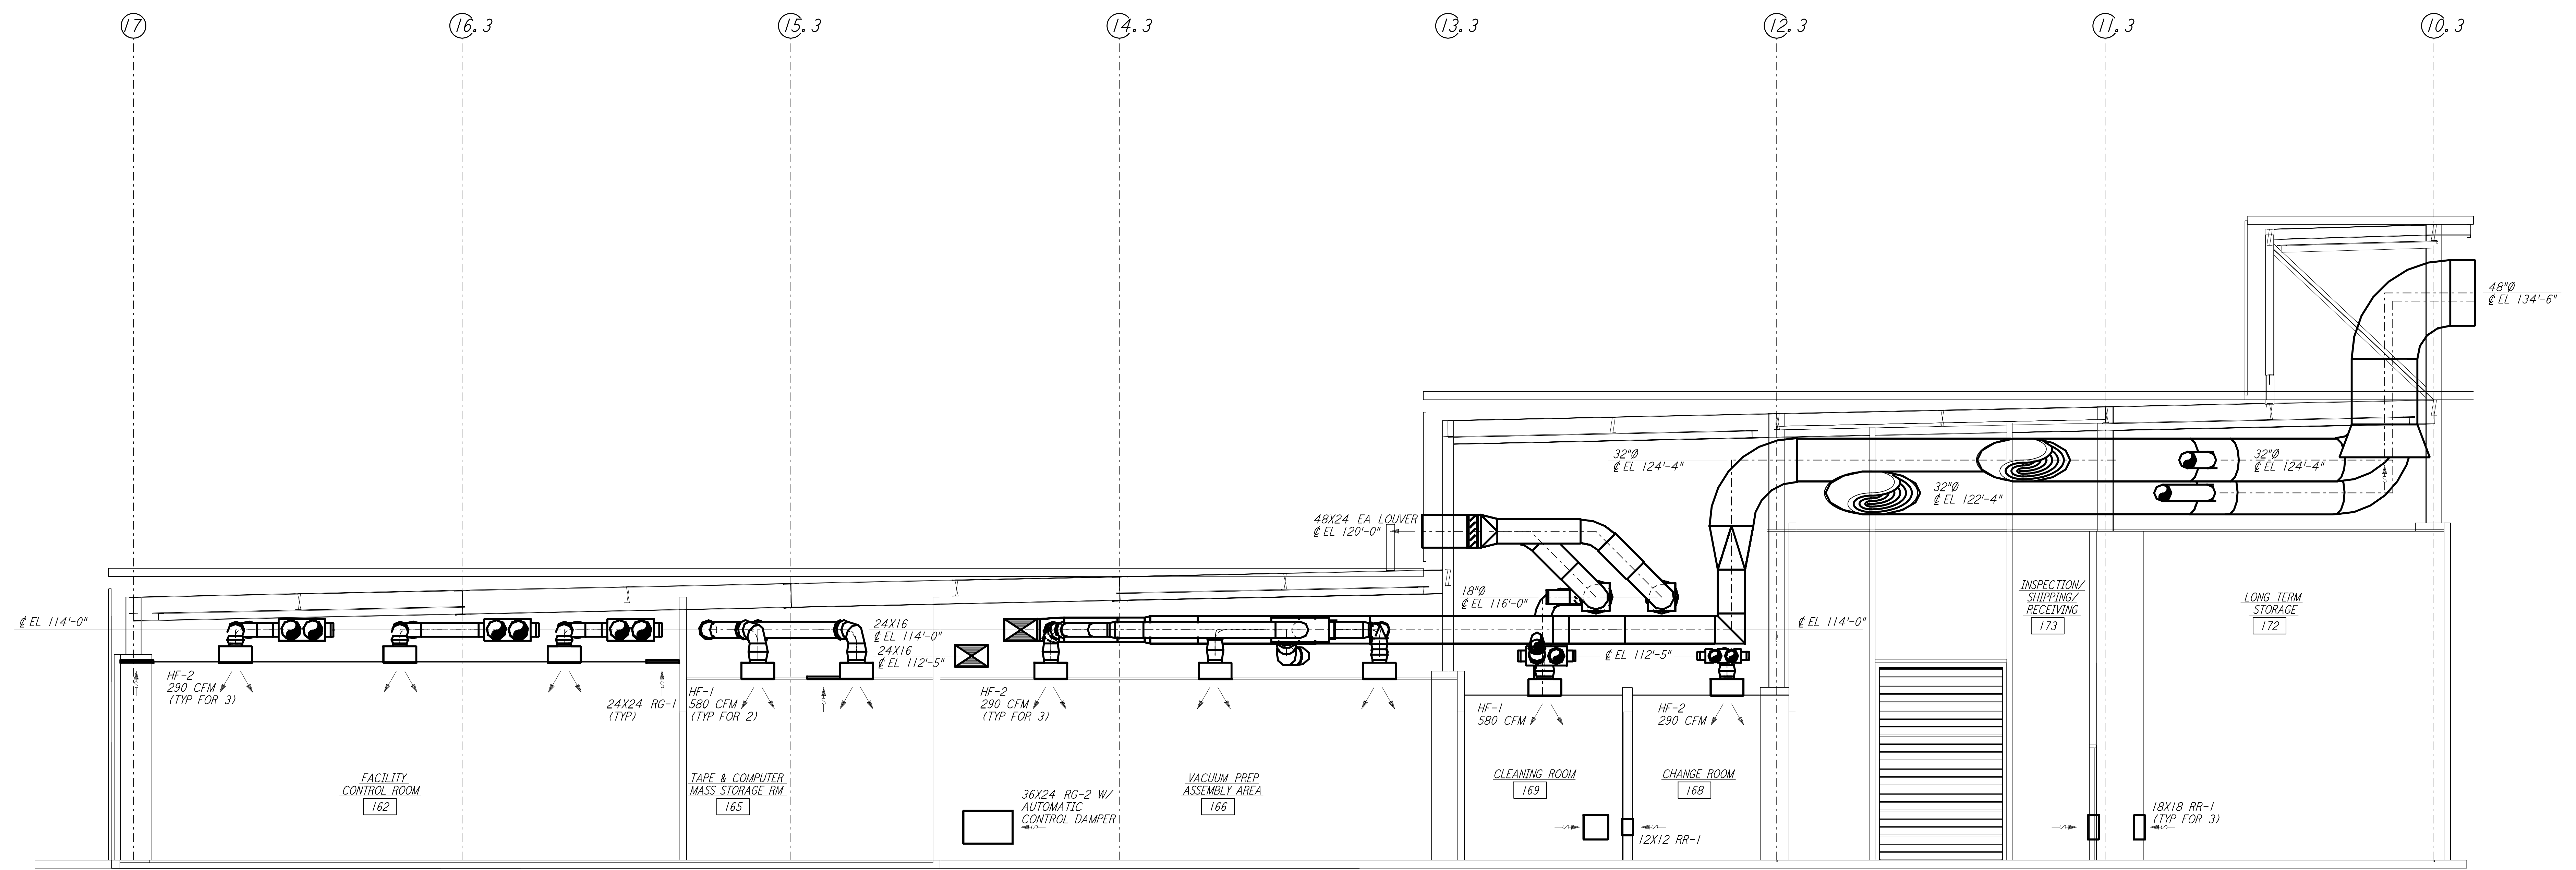

SECTION D  
 1/4" = 1'-0"

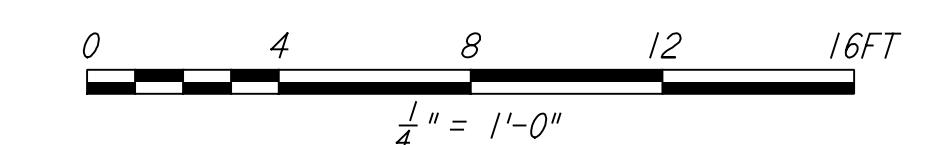

This document and the design it covers are the property of PARSONS. They are loaned only with the borrower's expressed written agreement that they will not be reproduced, copied, loaned, exhibited, or used in any other way, except by written consent from PARSONS to the borrower.

NO.	DATE	BY	CHKD	ENGR	PROJ	DESCRIPTION
1	5-15-98	CP				ISSUED FOR AS-BUILT

AS-BUILT DRAWINGS

ISSUED FOR CONSTRUCTION  
 DRAWN CLP 6-24-96  
 CHECKED  
 ENGINEER  
 PROJ



**LIGO-D960359-01-O**

LASER INTERFEROMETER  
 GRAVITATIONAL-WAVE OBSERVATORY  
 SITE NO. 1 - HANFORD, WASHINGTON

HVAC  
 CORNER STATION  
 SECTIONS SHEET 3

AS NOTED PP150969 8094  
**WA-H-153**