


MID STATION "A" CONTROL DIAGRAM  
 TYPICAL FOR MID STATION "B"

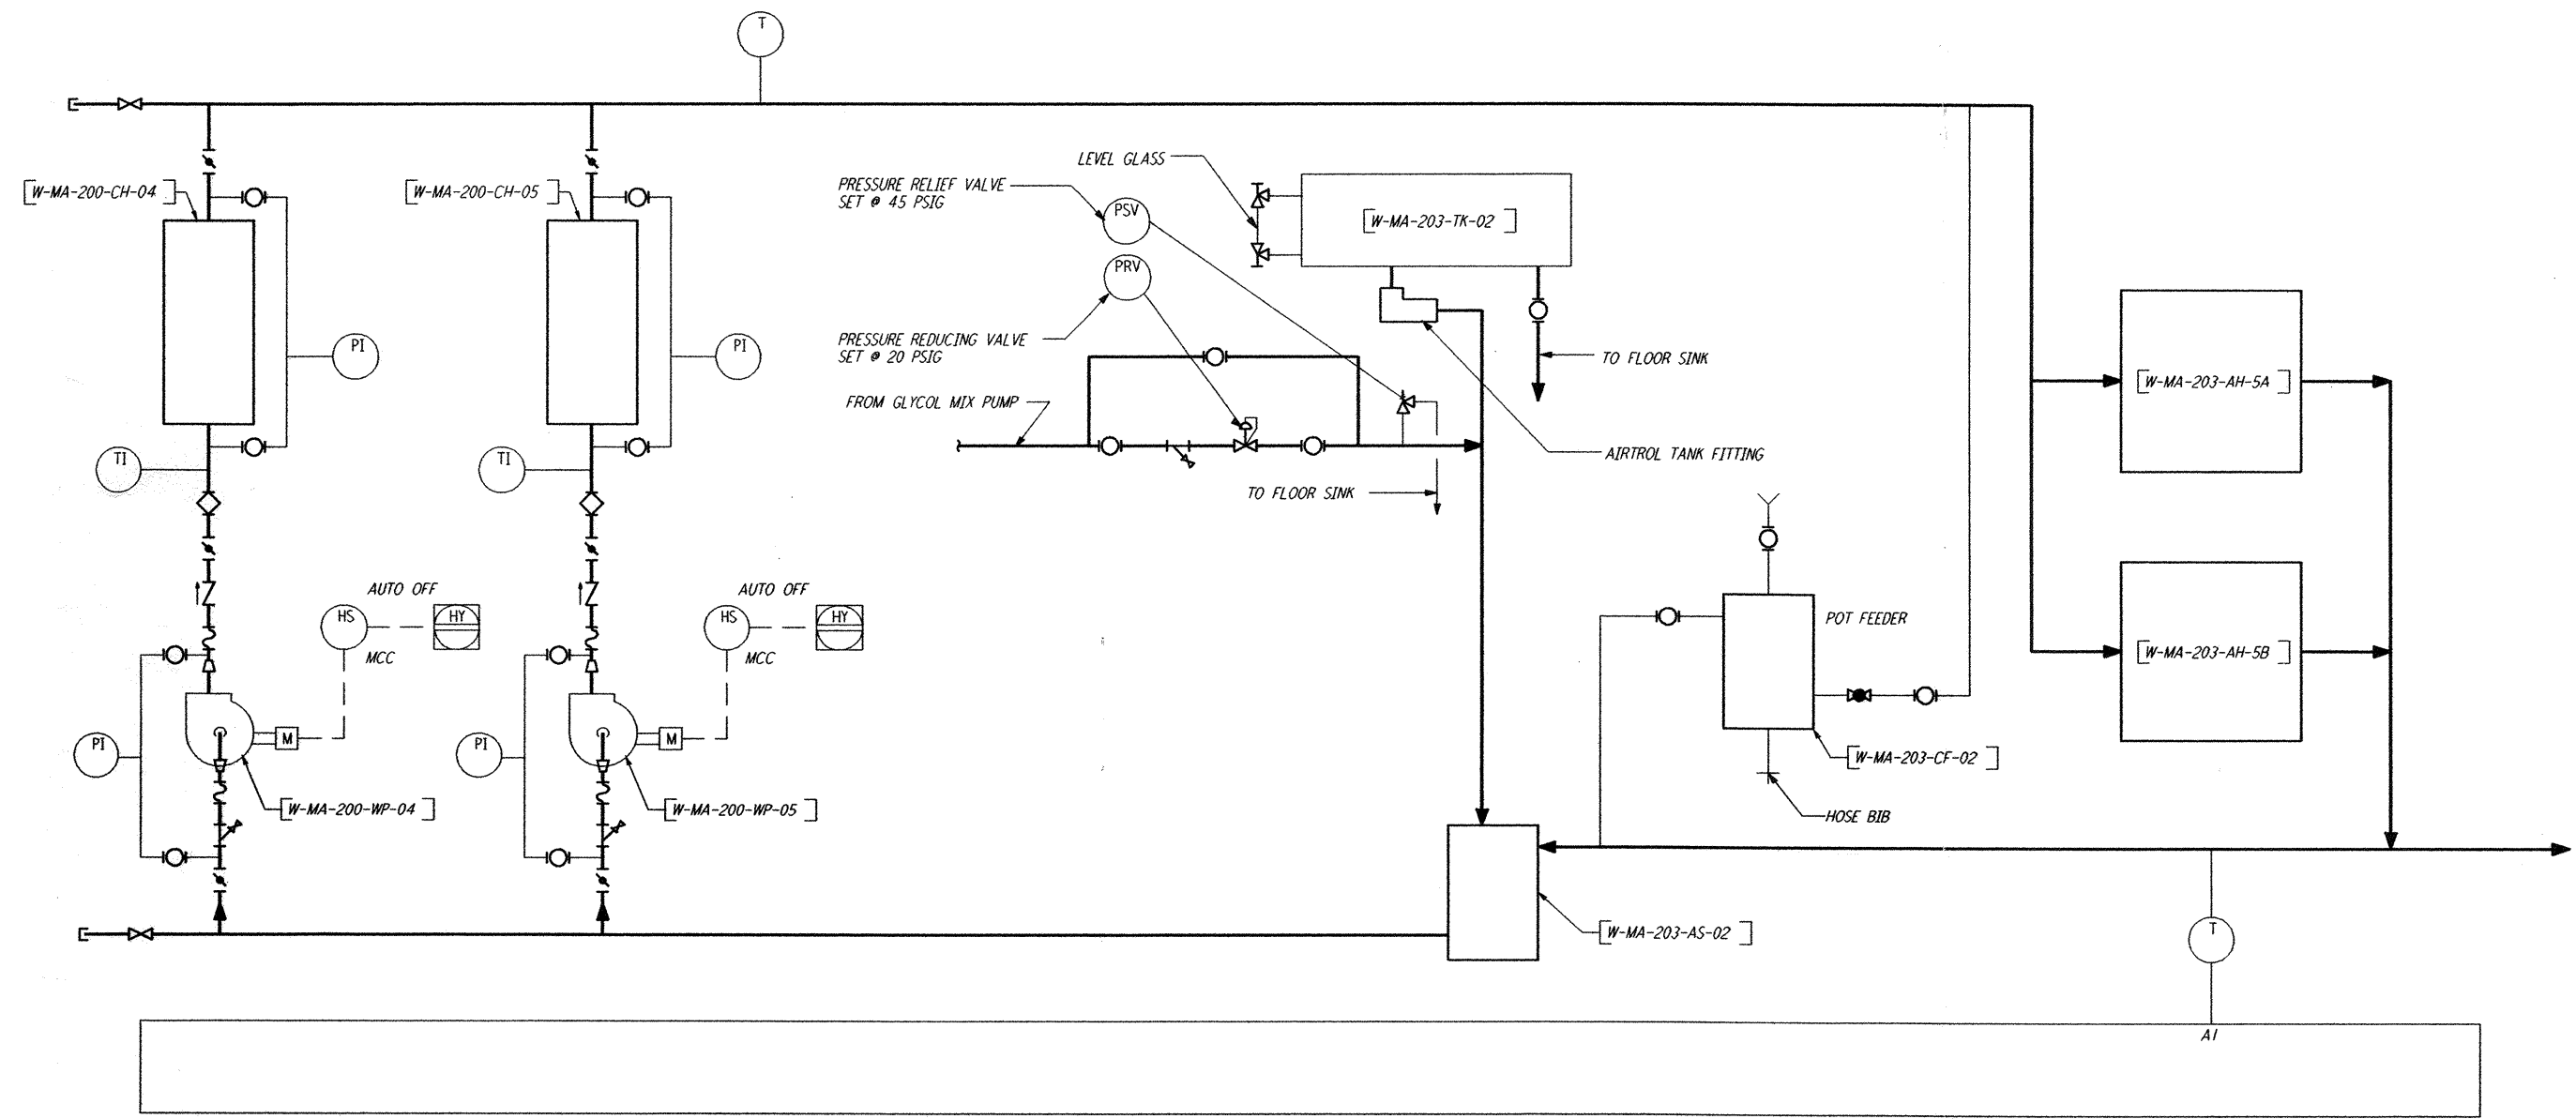

CHILLED WATER FLOW DIAGRAM AT MID STATION "A"  
 TYPICAL FOR MID STATION "B"

not be reproduced, copied, loaned, exhibited, or used in any other way, except by written consent from PARSONS to the borrower.

This document and the design it covers are the property of PARSONS. They are loaned only with the borrower's expressed written agreement that they will

NO.	DATE	APRD BY	DESCRIPTION OF REVISION
9			
8			
7			
6			
5			
4			
3			
2			
1			

ISSUE	NO.	DATE	APRD BY	DESCRIPTION OF REVISION
J				
H				
G				
F				
E				
D				
C				
B				
A	10/31/95	TDM		PRELIMINARY DESIGN REVIEW

DATE	10/31/95
DRAWN	CLP
CHECKED	
ENGINEER	
PROJ MGR	



LASER INTERFEROMETER GRAVITATIONAL-WAVE OBSERVATORY SITE NO. 1 - HANFORD, WASHINGTON		
TITLE	SHEET NUMBER	PROJECT NUMBER
MID STATION AIR FLOW AND CHILLED WATER DIAGRAM	NONE PPI50969	8094
WA-H-221		REVISIONS

Mon Oct 30 21:27:12 1995 S3-V18B2 J:\PLOTS\QUEUES\V18B2\MU221C.PRF