


**NOTES:**


1. FOR LEGEND, ABBREVIATIONS AND GENERAL NOTES SEE SHEETS WA-H-001 AND WA-H-002.

not be reproduced, copied, loaned, exhibited, or used in any other way, except by written consent from PARSONS to the borrower.


This document and the design it covers are the property of PARSONS. They are loaned only with the borrower's expressed written agreement that they will

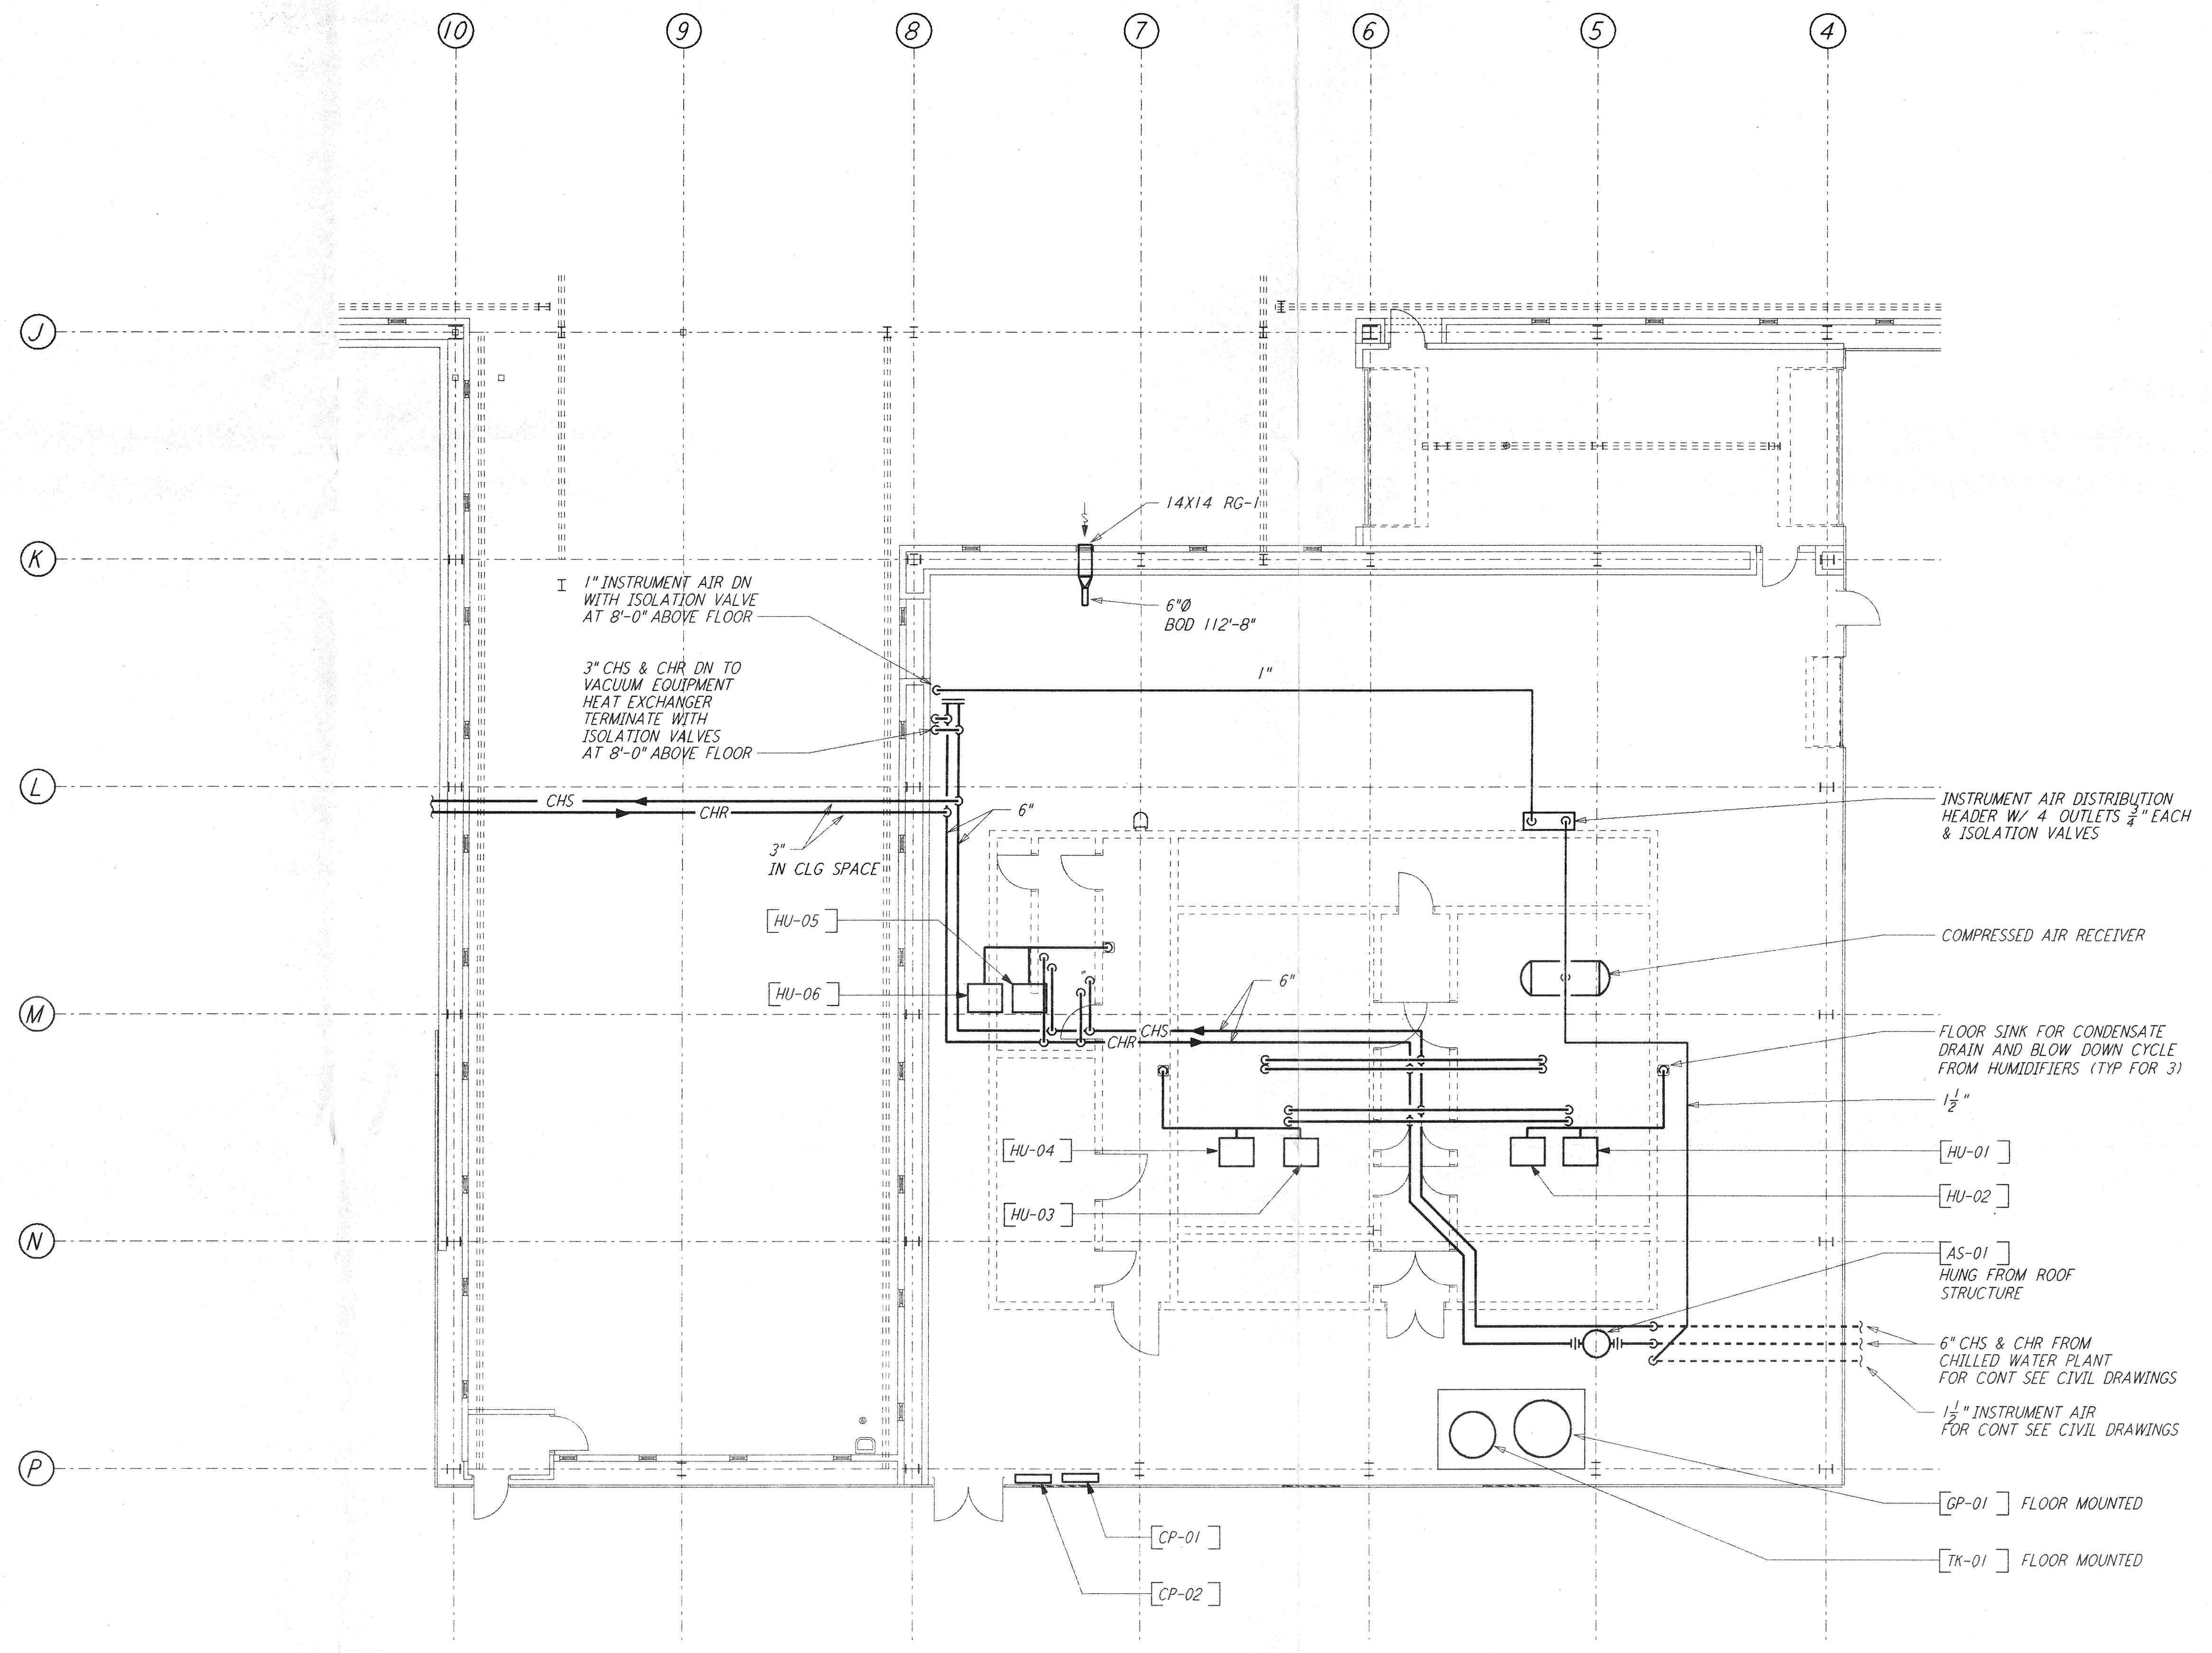

**MECHANICAL ROOM PLAN**  
 $\frac{1}{8}'' = 1'-0''$

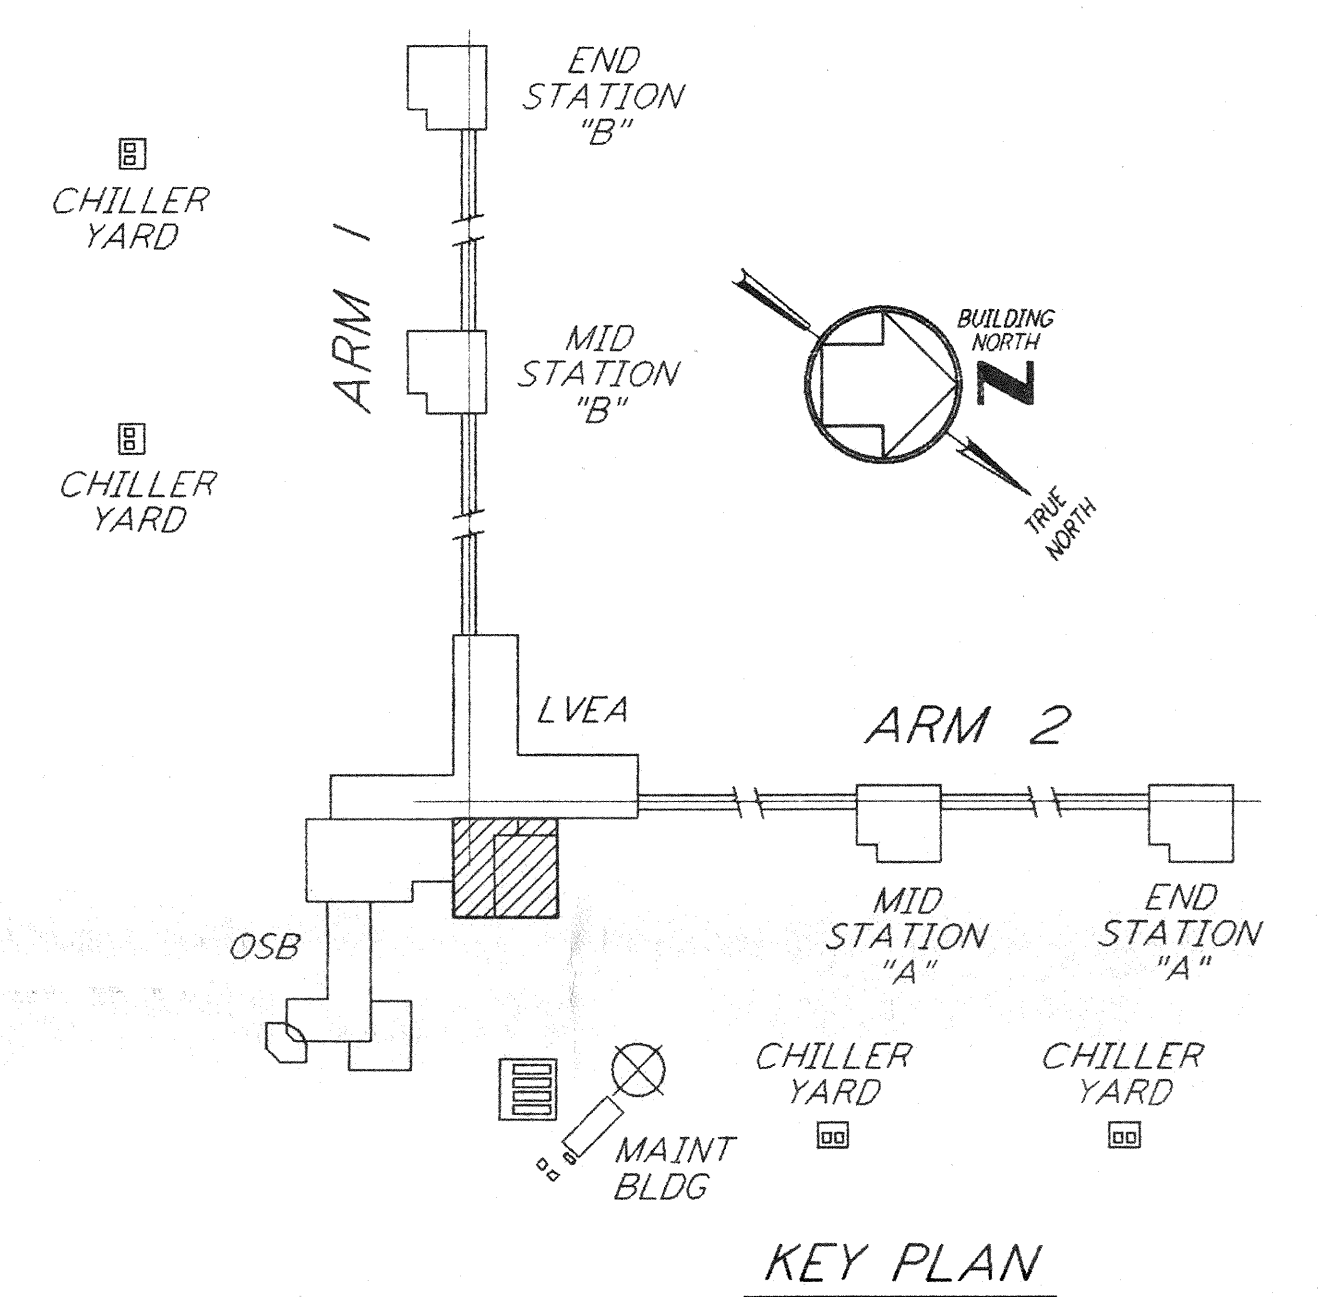


**KEY PLAN**

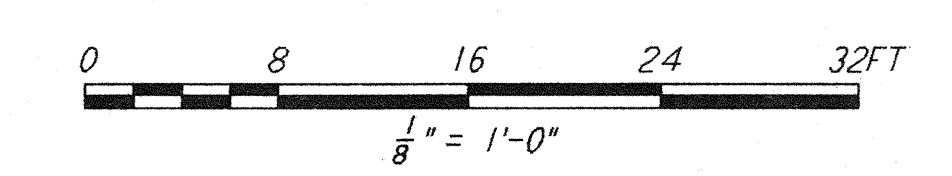

REFERENCES		REVISIONS						
DRAWING NO.	DESCRIPTION	NO.	DATE	BY	CHKD	ENGR	PROJ	DESCRIPTION

ISSUED FOR CONSTRUCTION			
DRAWN	CLP	6-24-96	
CHECKED	ME	7/3/96	
ENGINEER	AA	7/3/96	
PROJ			

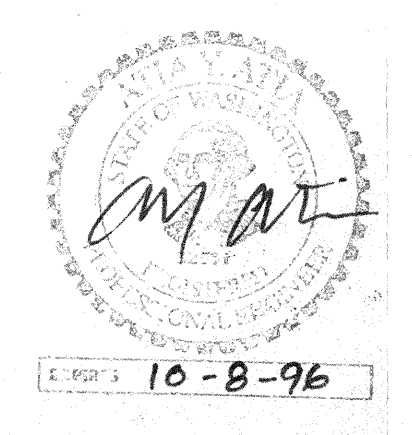

**PARSONS**  
 100 WEST WALNUT STREET  
 PASADENA, CALIFORNIA

**LIGO**  
 CALIFORNIA INSTITUTE OF TECHNOLOGY  
 MASSACHUSETTS INSTITUTE OF TECHNOLOGY

LASER INTERFEROMETER  
 GRAVITATIONAL-WAVE OBSERVATORY  
 SITE NO. 1 - HANFORD, WASHINGTON

TITLE	SCALE	CONTRACT NUMBER	PROJECT NUMBER
HVAC CORNER STATION LVEA & OSB MECHANICAL ROOM PIPING PLAN	AS NOTED	PPI 50969	8094
SHEET NUMBER		REVISIONS	
<b>WA - H - 513</b>			

LIGO-D980383-00-0  
 LICOWAF 3.BDR