

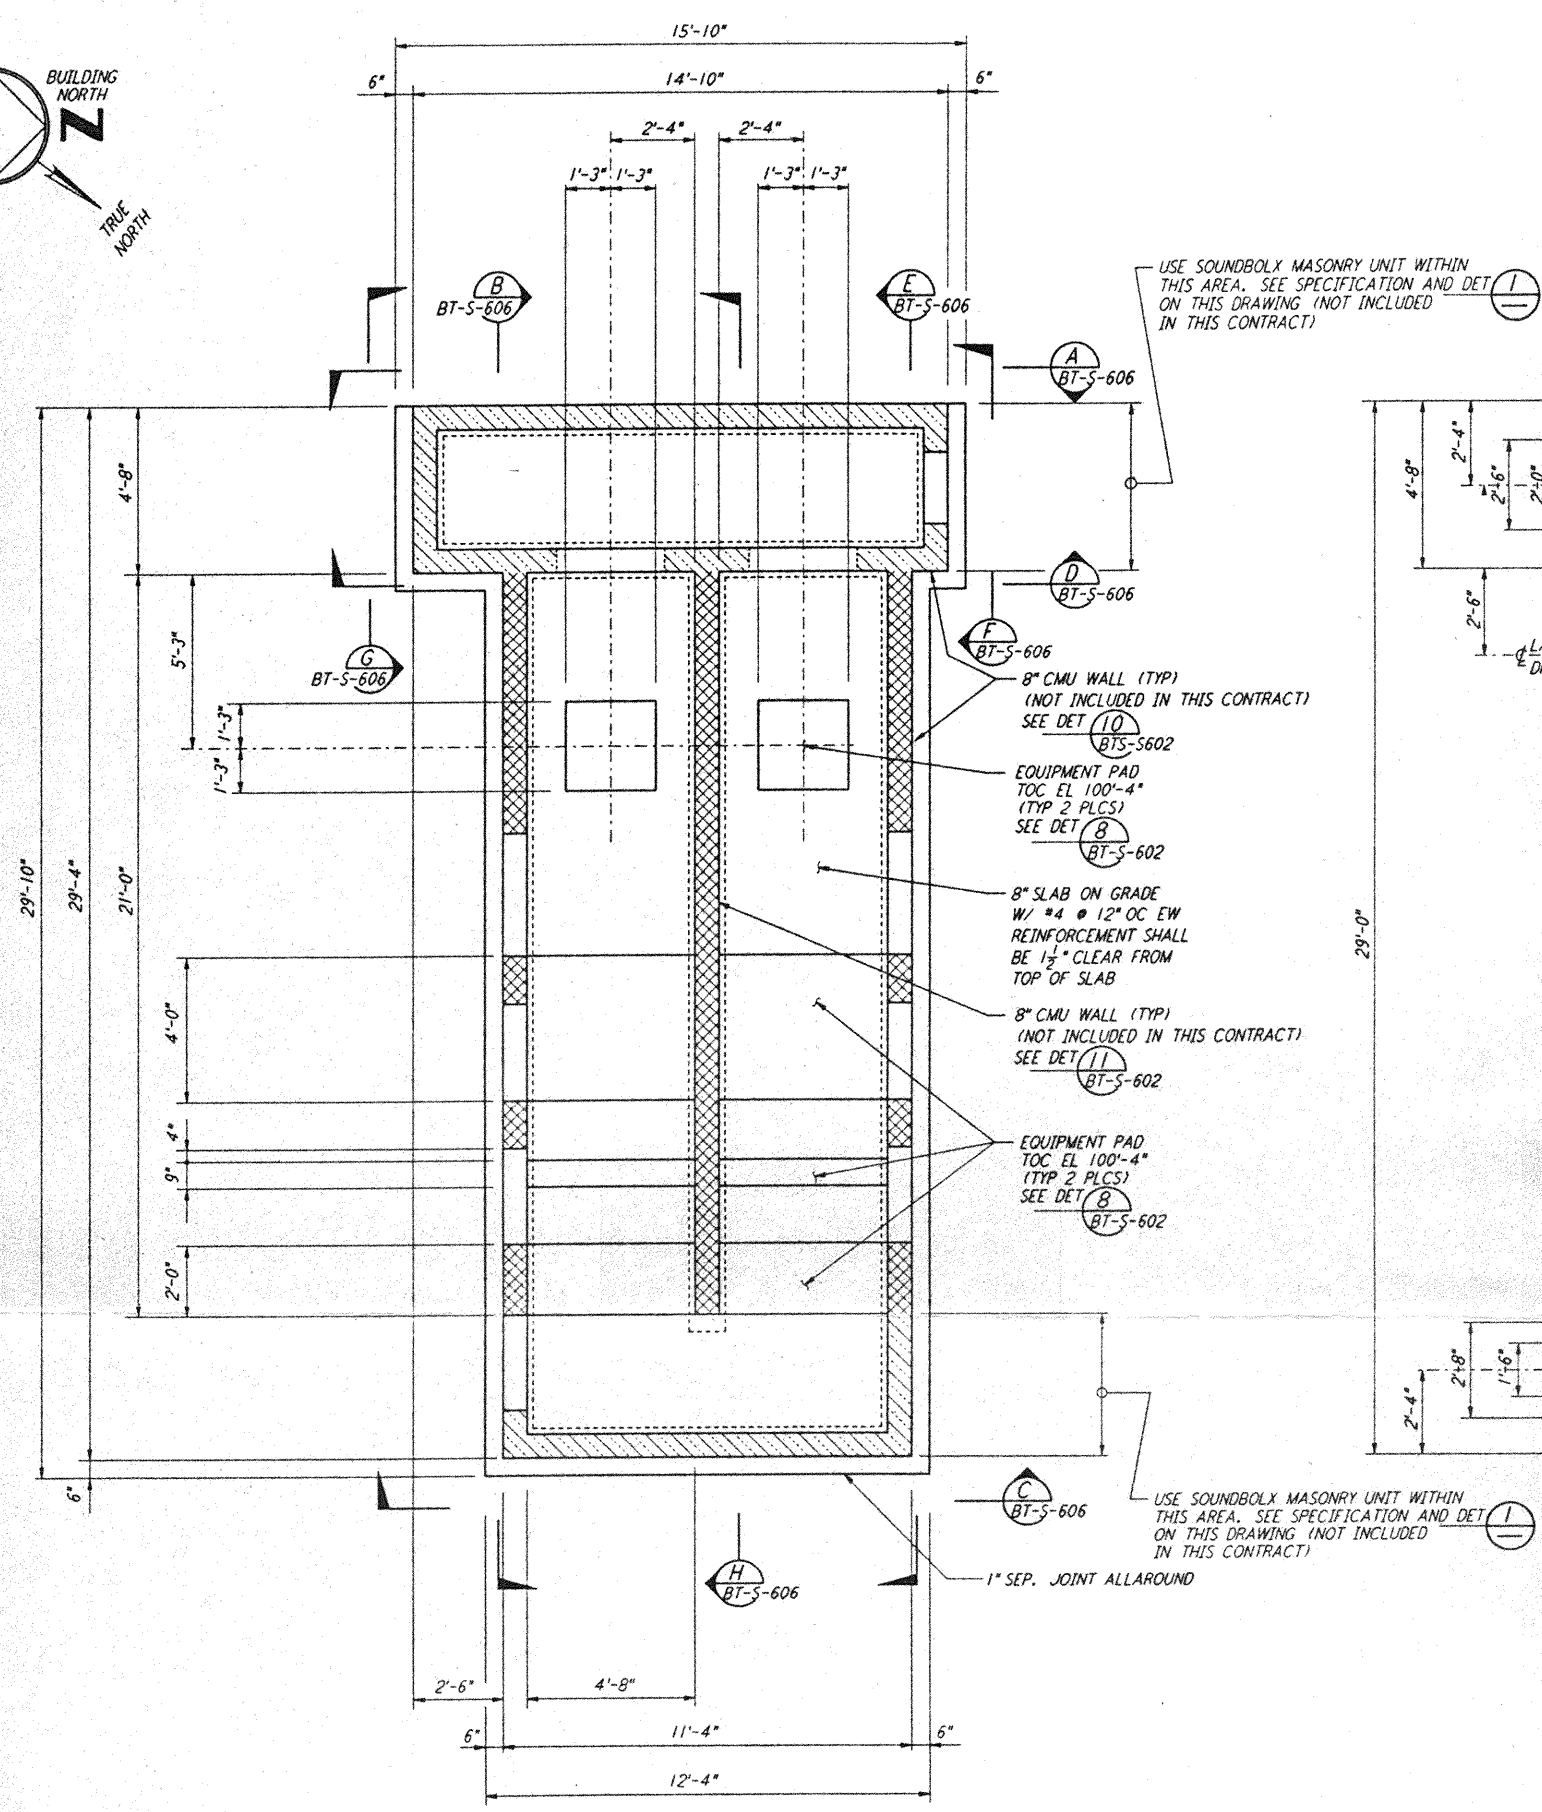



This document and the design it covers are the property of PARSONS. They are loaned only with the borrower's expressed written agreement that they will not be reproduced, copied, loaned, exhibited, or used in any other way, except by written consent from PARSONS to the borrower.

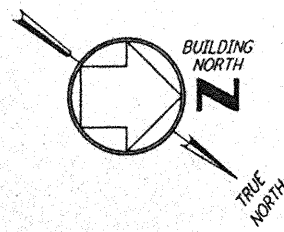


**AIR HANDLING UNIT STRUCTURE
FOUNDATION PLAN**
1/8" = 1'-0"

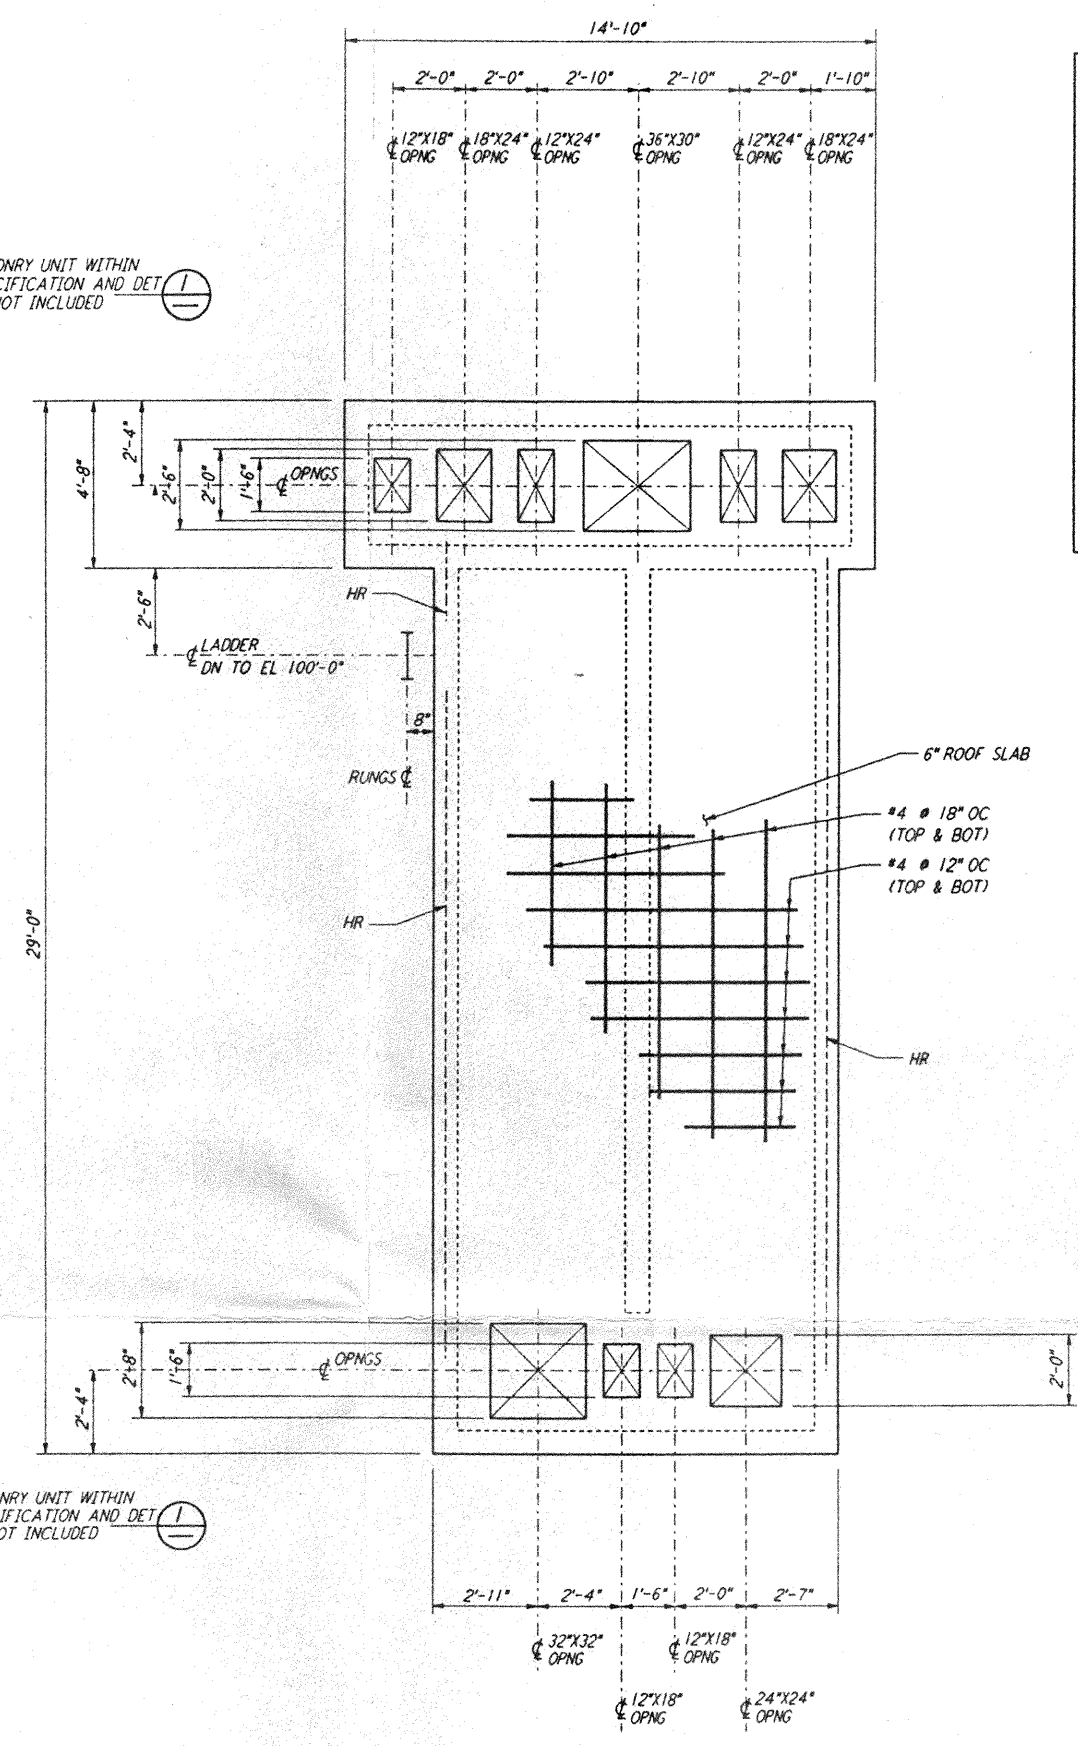

**AIR HANDLING UNIT STRUCTURE
CONCRETE ROOF SLAB PLAN**
1/8" = 1'-0" — NOT INCLUDED IN THIS CONTRACT

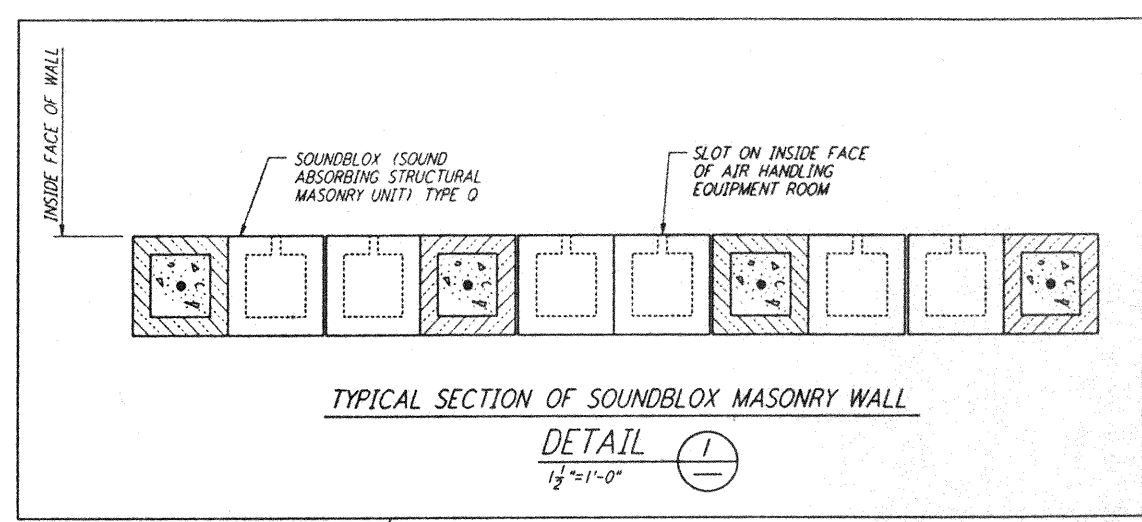

NOT INCLUDED IN THIS CONTRACT

 

NO.	DATE	BY	CHKD	ENGR	PROJ	DESCRIPTION
A	4-19-96	MCS	MS	BP	Yubk	CHANGE ORDER #4

DRAWN	MCS
CHECKED	
ENGINEER	
PROJ	

PARSONS
100 WEST WALNUT STREET
PASADENA, CALIFORNIA

LIGO
CALIFORNIA INSTITUTE OF TECHNOLOGY
MASSACHUSETTS INSTITUTE OF TECHNOLOGY

LASER INTERFEROMETER
GRAVITATIONAL-WAVE OBSERVATORY
BTE SITEWORK & FABRICATION - HANFORD, WA

TITLE	SCALE	CONTRACT NUMBER	PROJECT NUMBER
STRUCTURAL MID & END STATIONS "B" AIR HANDLING UNIT ENCLOSURE PLANS	AS NOTED	PPI 50969	8094
BT-S-605		LIGO-09160739	