 

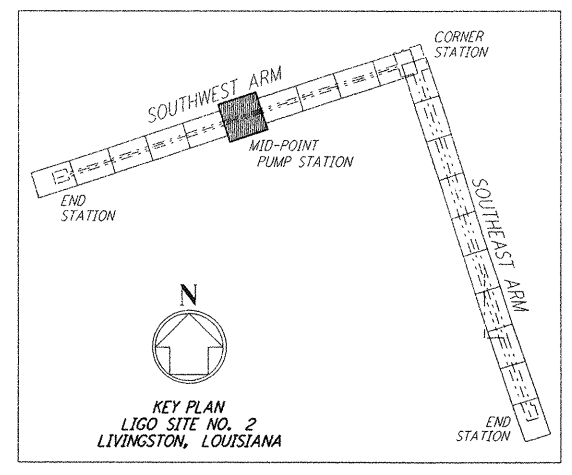
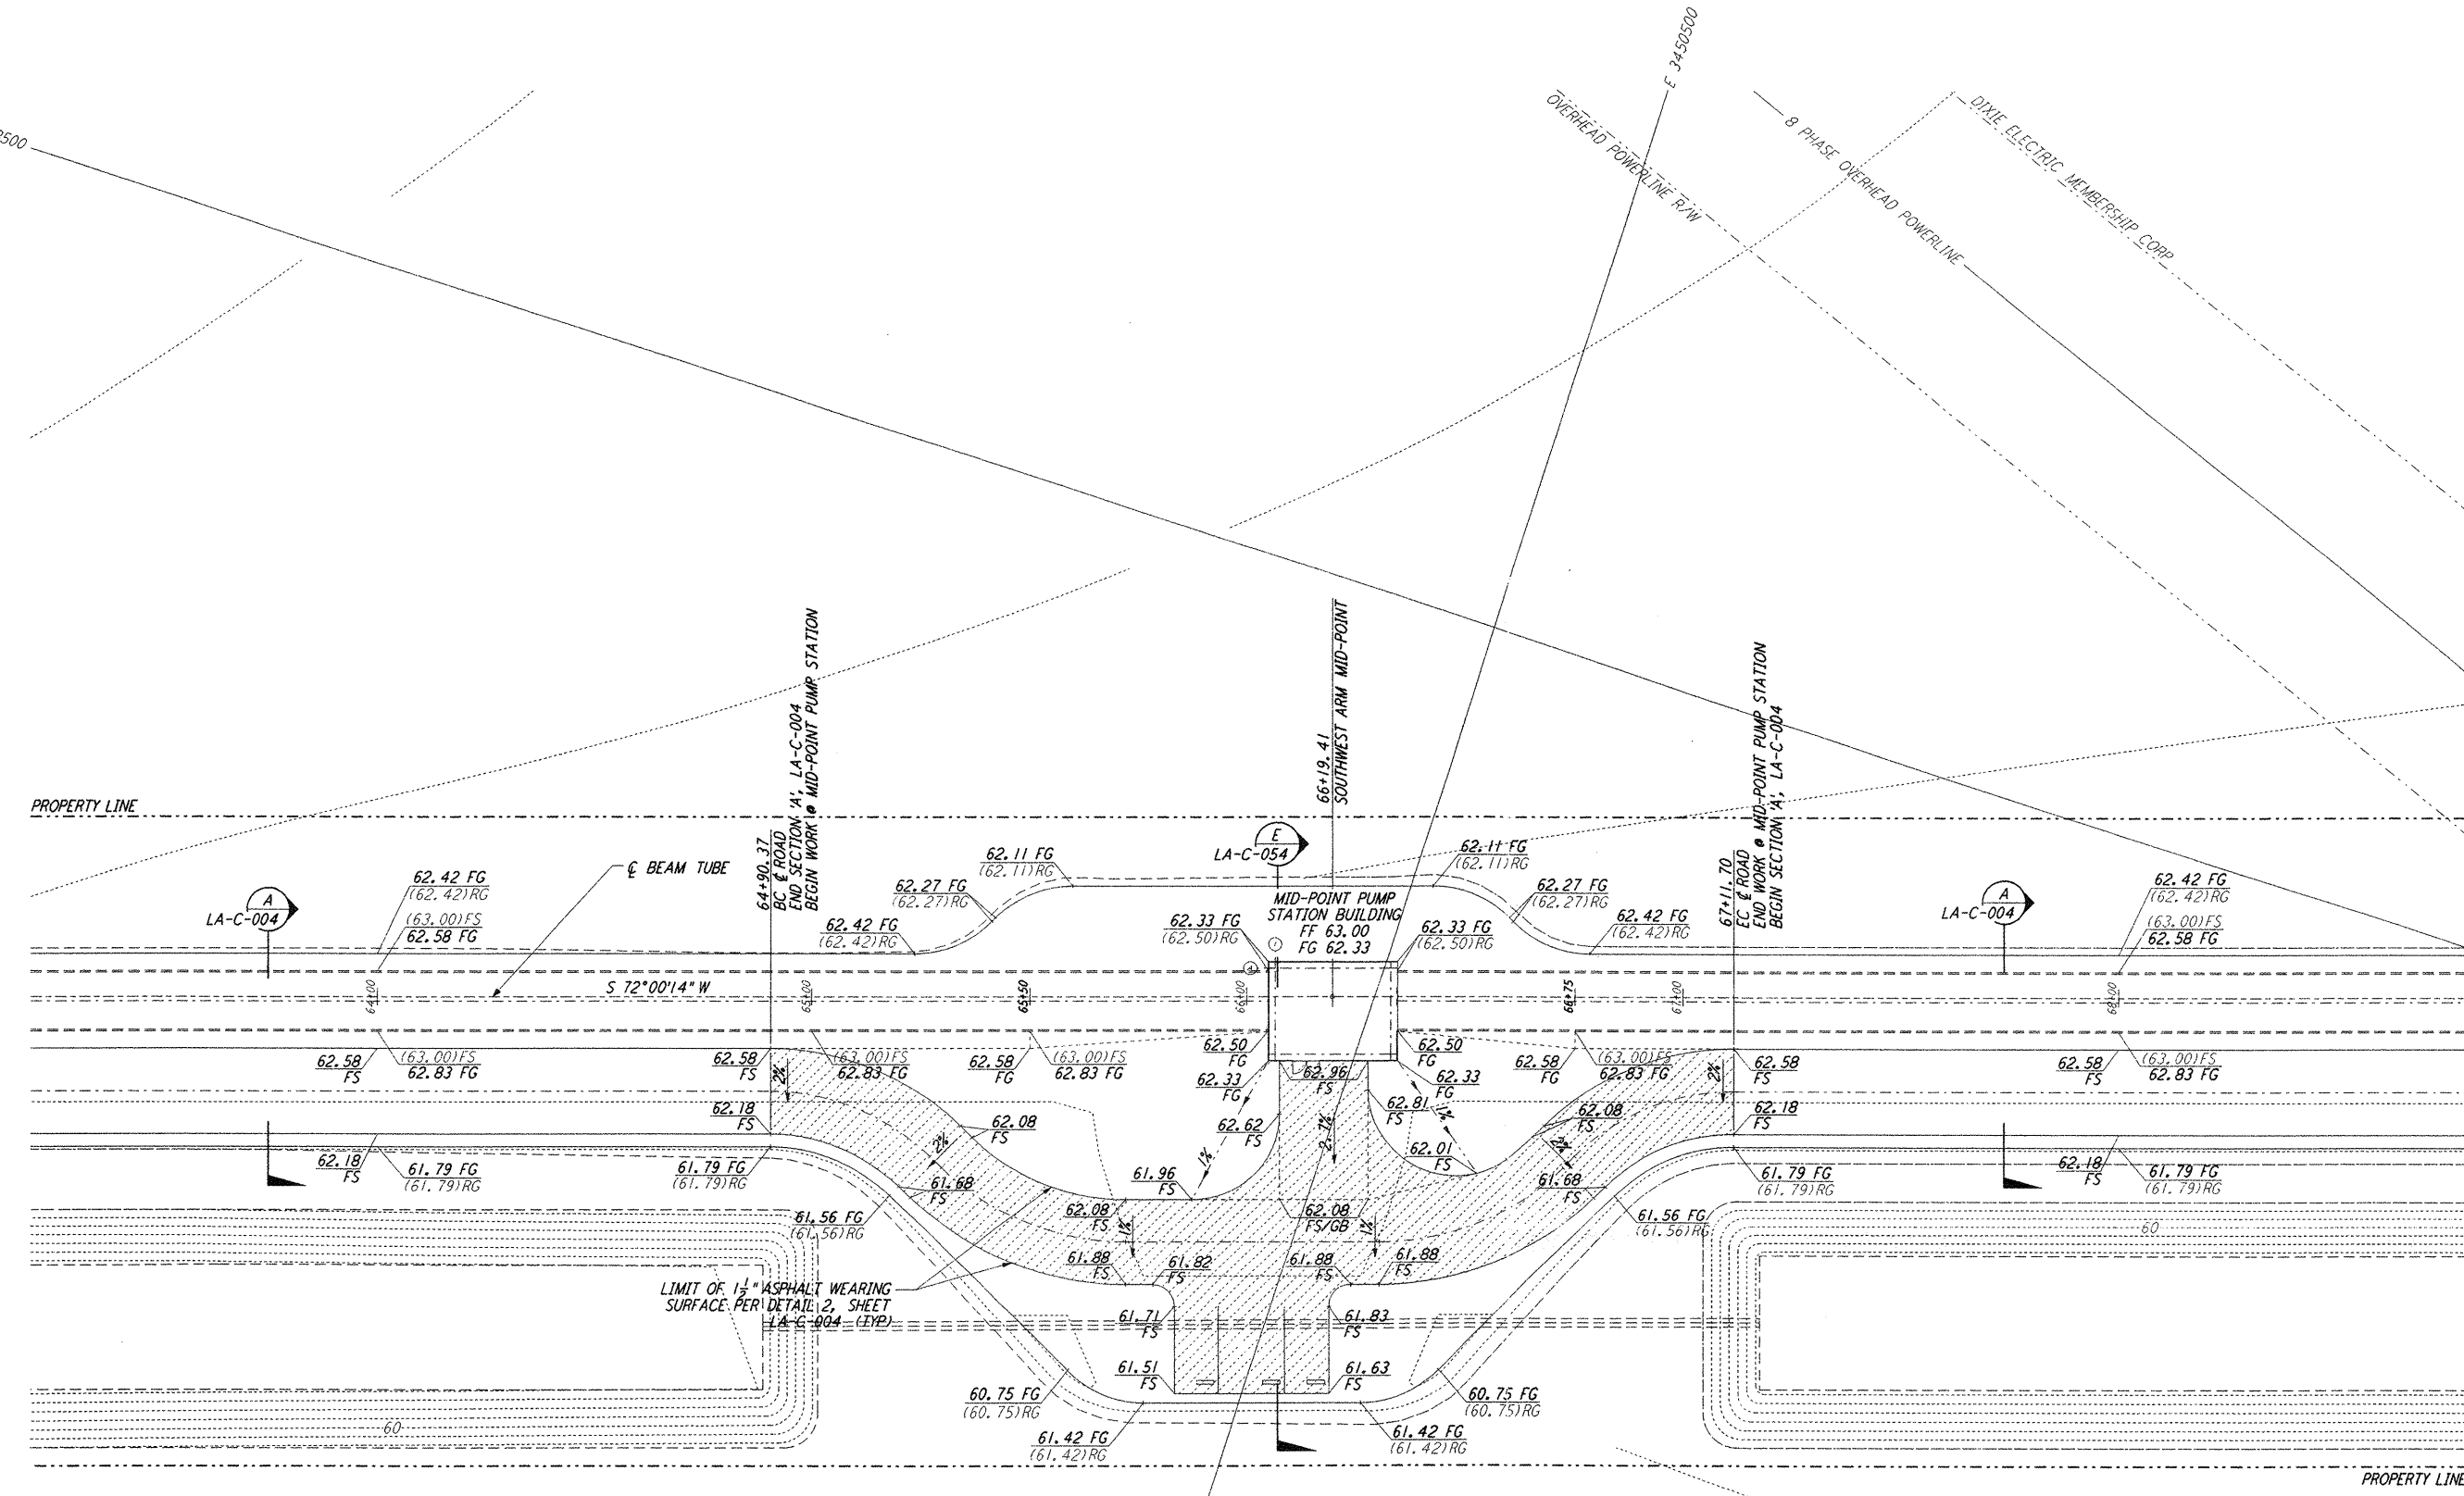


NOTES:
 1. SEE SHEET LA-C-002 FOR GENERAL NOTES, LEGEND AND ABBREVIATIONS.

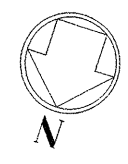

LIGO-D960840-02-0

LASER INTERFEROMETER
 GRAVITATIONAL-WAVE OBSERVATORY
 SITE NO. 2 - LIVINGSTON, LOUISIANA

TITLE	SCALE	CONTRACT NUMBER	PROJECT NUMBER
CIVIL SOUTHWEST ARM PUMP STATION GRADING PLAN	1" = 20'	PP150969	8094
SHEET NUMBER	REVISIONS		
LA-C-022			

LIGO
 CALIFORNIA INSTITUTE OF TECHNOLOGY
 MASSACHUSETTS INSTITUTE OF TECHNOLOGY

PARSONS
 100 WEST WALNUT STREET
 PASADENA, CALIFORNIA

ISSUED FOR CONSTRUCTION
 DRAWN: WRB 11-15-96
 CHECKED: ML 11-15-96
 ENGINEER: JB 11-15-96
 PROJ: TDM 11-15-96

AS-BUILT DRAWINGS

NO.	DATE	BY	CHKD	ENGR	PROJ	DESCRIPTION
2	08-07-98	WAB	MS	JB	WJW	ISSUED FOR AS-BUILT
1	2-3-97	WAB	ML	JB	TDM	REVISED MID STATION

DRAWING NO.	DESCRIPTION

This document and the design it covers are the property of PARSONS. They are loaned only with the borrower's expressed written agreement that they will not be reproduced, copied, loaned, exhibited, or used in any other way, except by written consent from PARSONS to the borrower.

E
 D
 C
 B
 A
 LIG0LAF3.BDR
 Sun Aug 23 22:08:47 1998 C:\PLOT\QUE\53-T3882.dwg 52885 K:\T3882\ce022.prf