 

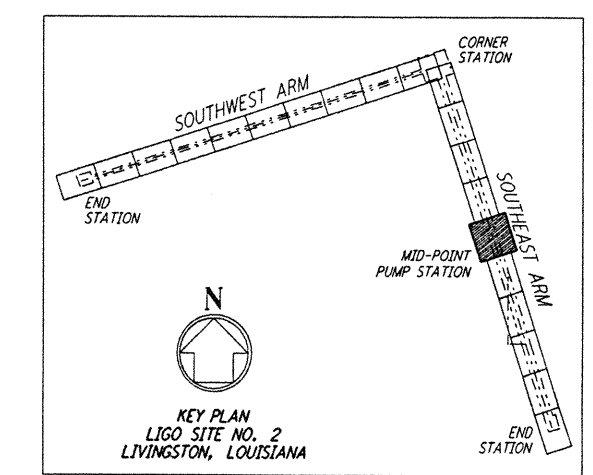


NOTES:
 1. SEE SHEET LA-C-002 FOR GENERAL NOTES, LEGEND AND ABBREVIATIONS.

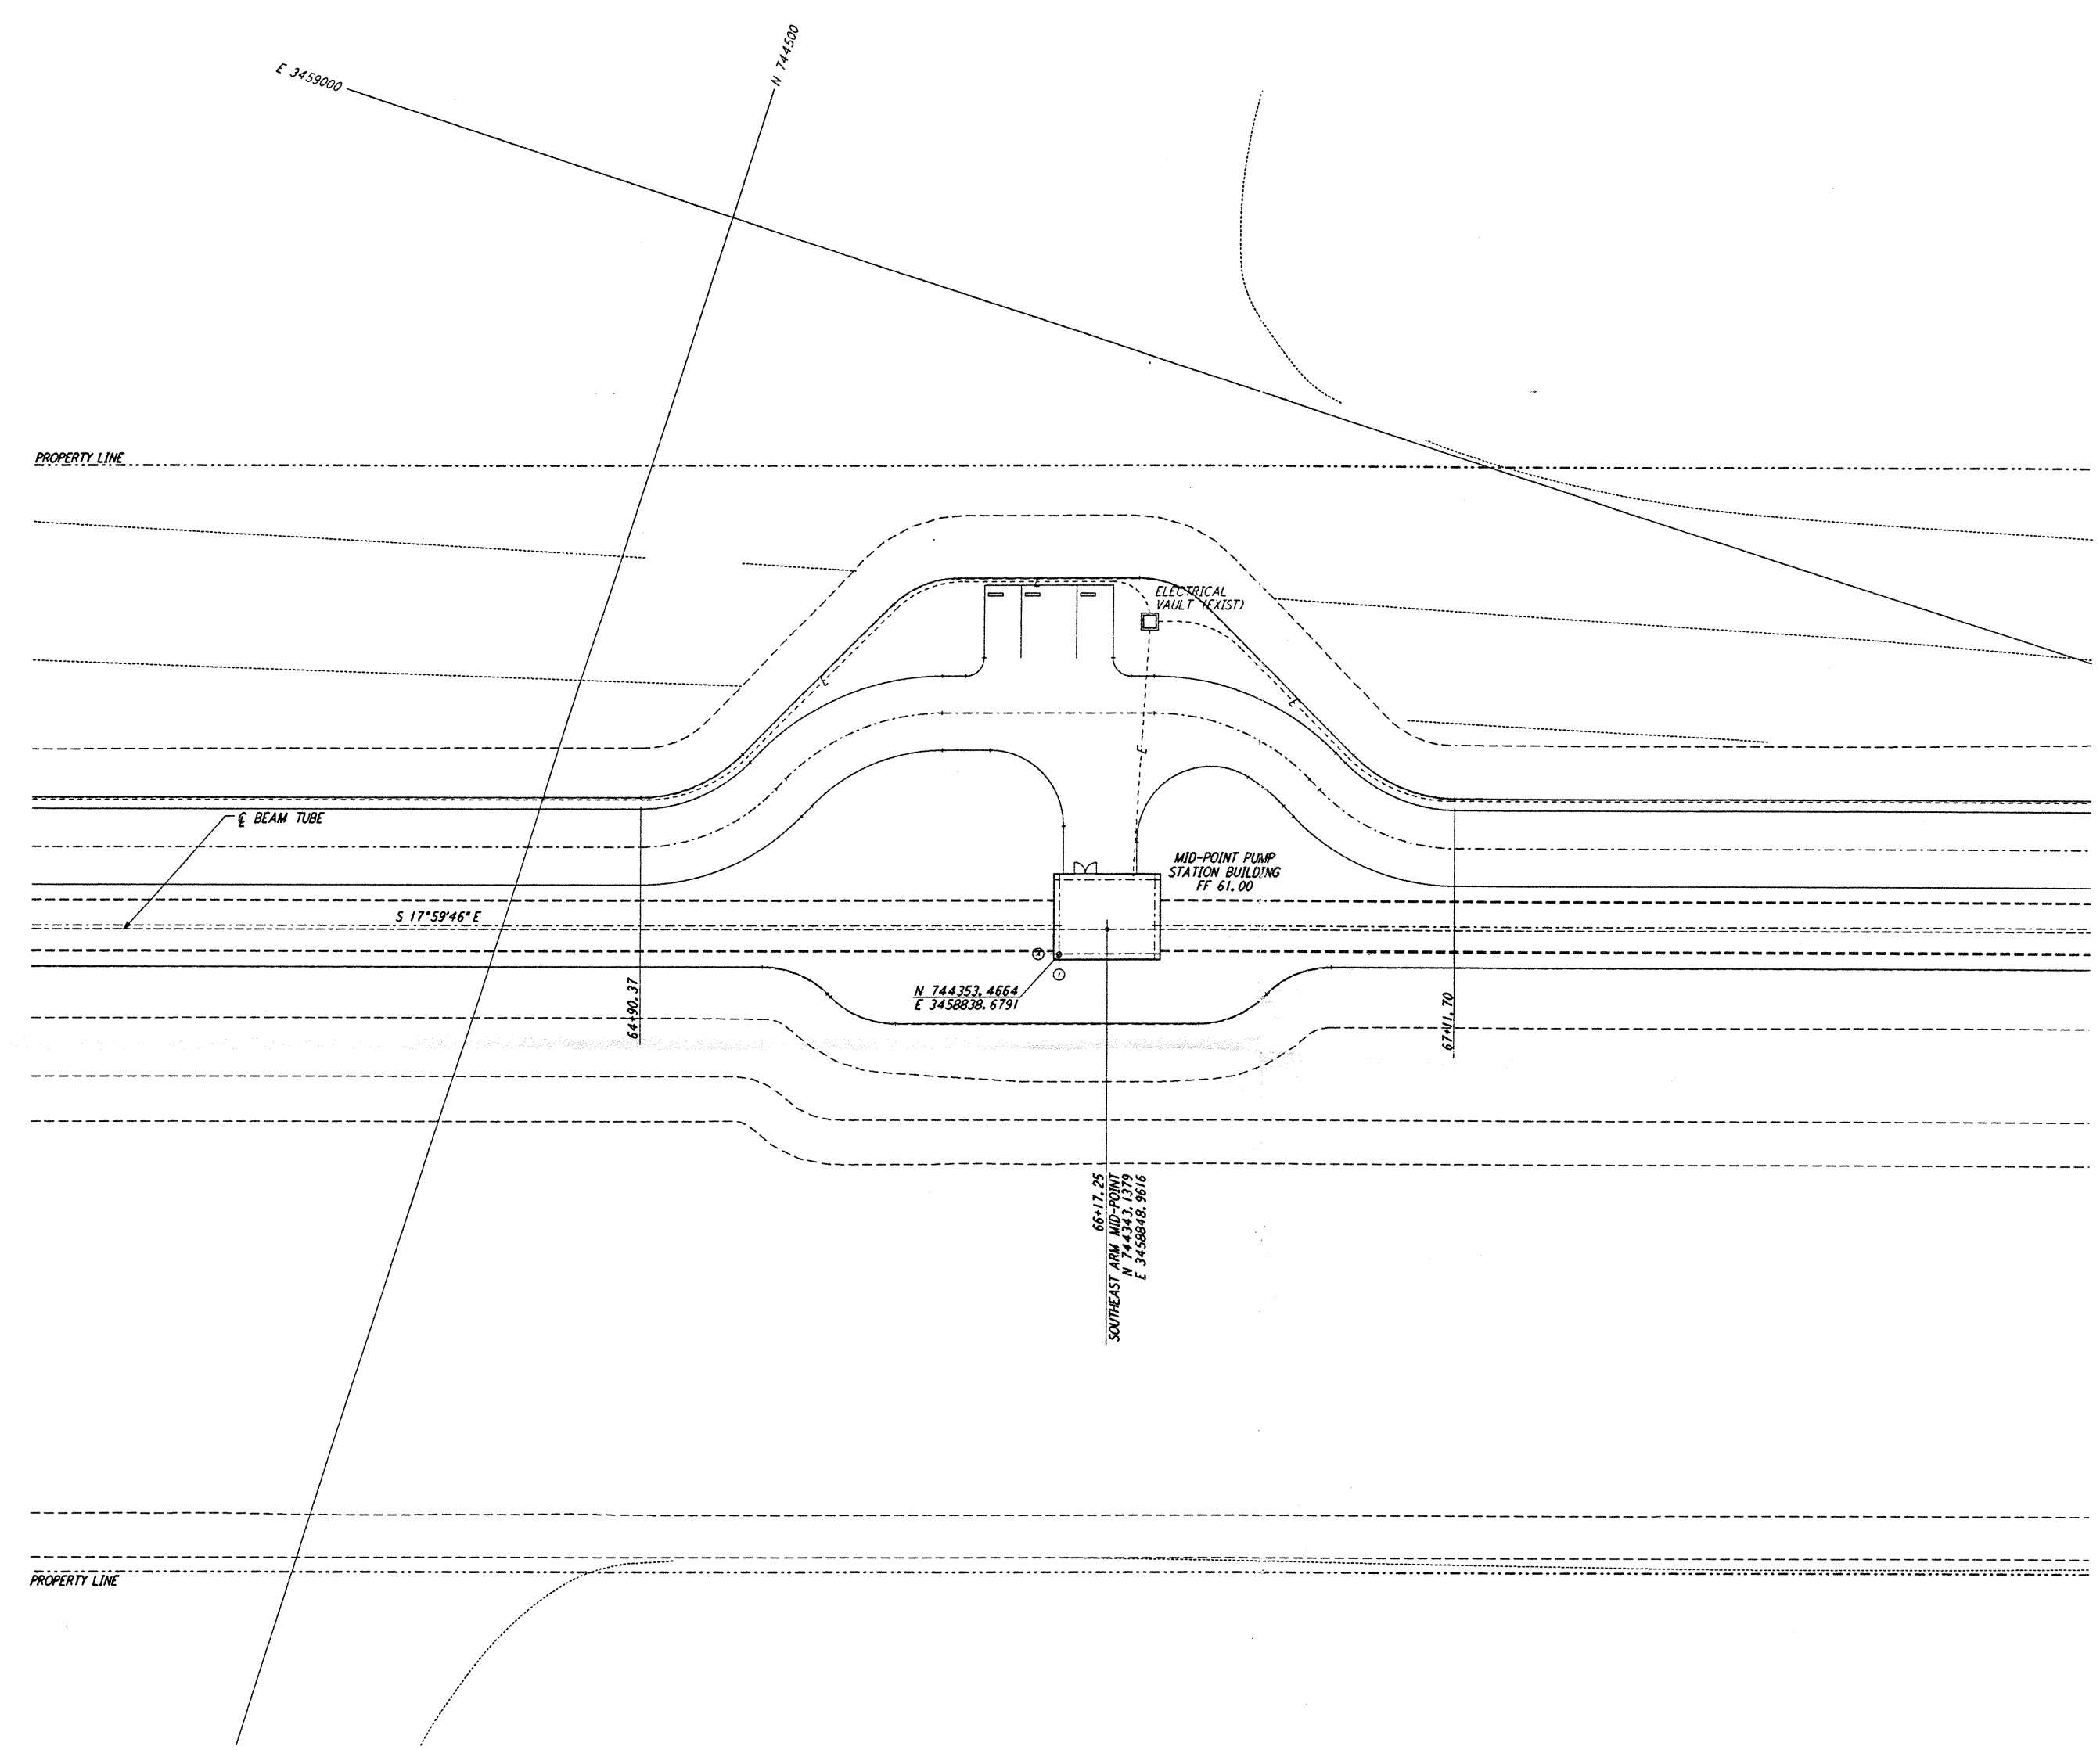

LIGO-D960857-A-O

NO.	DATE	BY	CHKD	ENGR	PROJ	DESCRIPTION
A	6/14/96	WRB	NA	0	5001	FINAL DESIGN REVIEW

DRAWN	WRB
CHECKED	
ENGINEER	
PROJ	

PARSONS
 100 WEST WALNUT STREET
 PASADENA, CALIFORNIA

LIGO
 CALIFORNIA INSTITUTE OF TECHNOLOGY
 MASSACHUSETTS INSTITUTE OF TECHNOLOGY

LASER INTERFEROMETER
 GRAVITATIONAL-WAVE OBSERVATORY
 SITE NO. 2 - LIVINGSTON, LOUISIANA

TITLE	SCALE	SHEET NUMBER	PROJECT NUMBER
CIVIL SOUTHWEST ARM PUMP STATION UTILITY PLAN	1" = 20'	PP150969	8094
SHEET NUMBER		REVISION	
LA-C-043			

This document and the design it covers are the property of PARSONS. They are loaned only with the borrower's expressed written agreement that they will not be reproduced, copied, loaned, exhibited, or used in any other way, except by written consent from PARSONS to the borrower.

600 MAIN ST. (221)320-1170, 5770BBL, JAYLEIS@PARSONS.COM, JAYLEIS@PARSONS.COM

600 MAIN ST. (221)320-1170, 5770BBL, JAYLEIS@PARSONS.COM, JAYLEIS@PARSONS.COM