



NOTES:
 1. FOR LEGEND, ABBREVIATIONS AND GENERAL NOTES SEE SHEETS LA-H-001 AND LA-H-002.

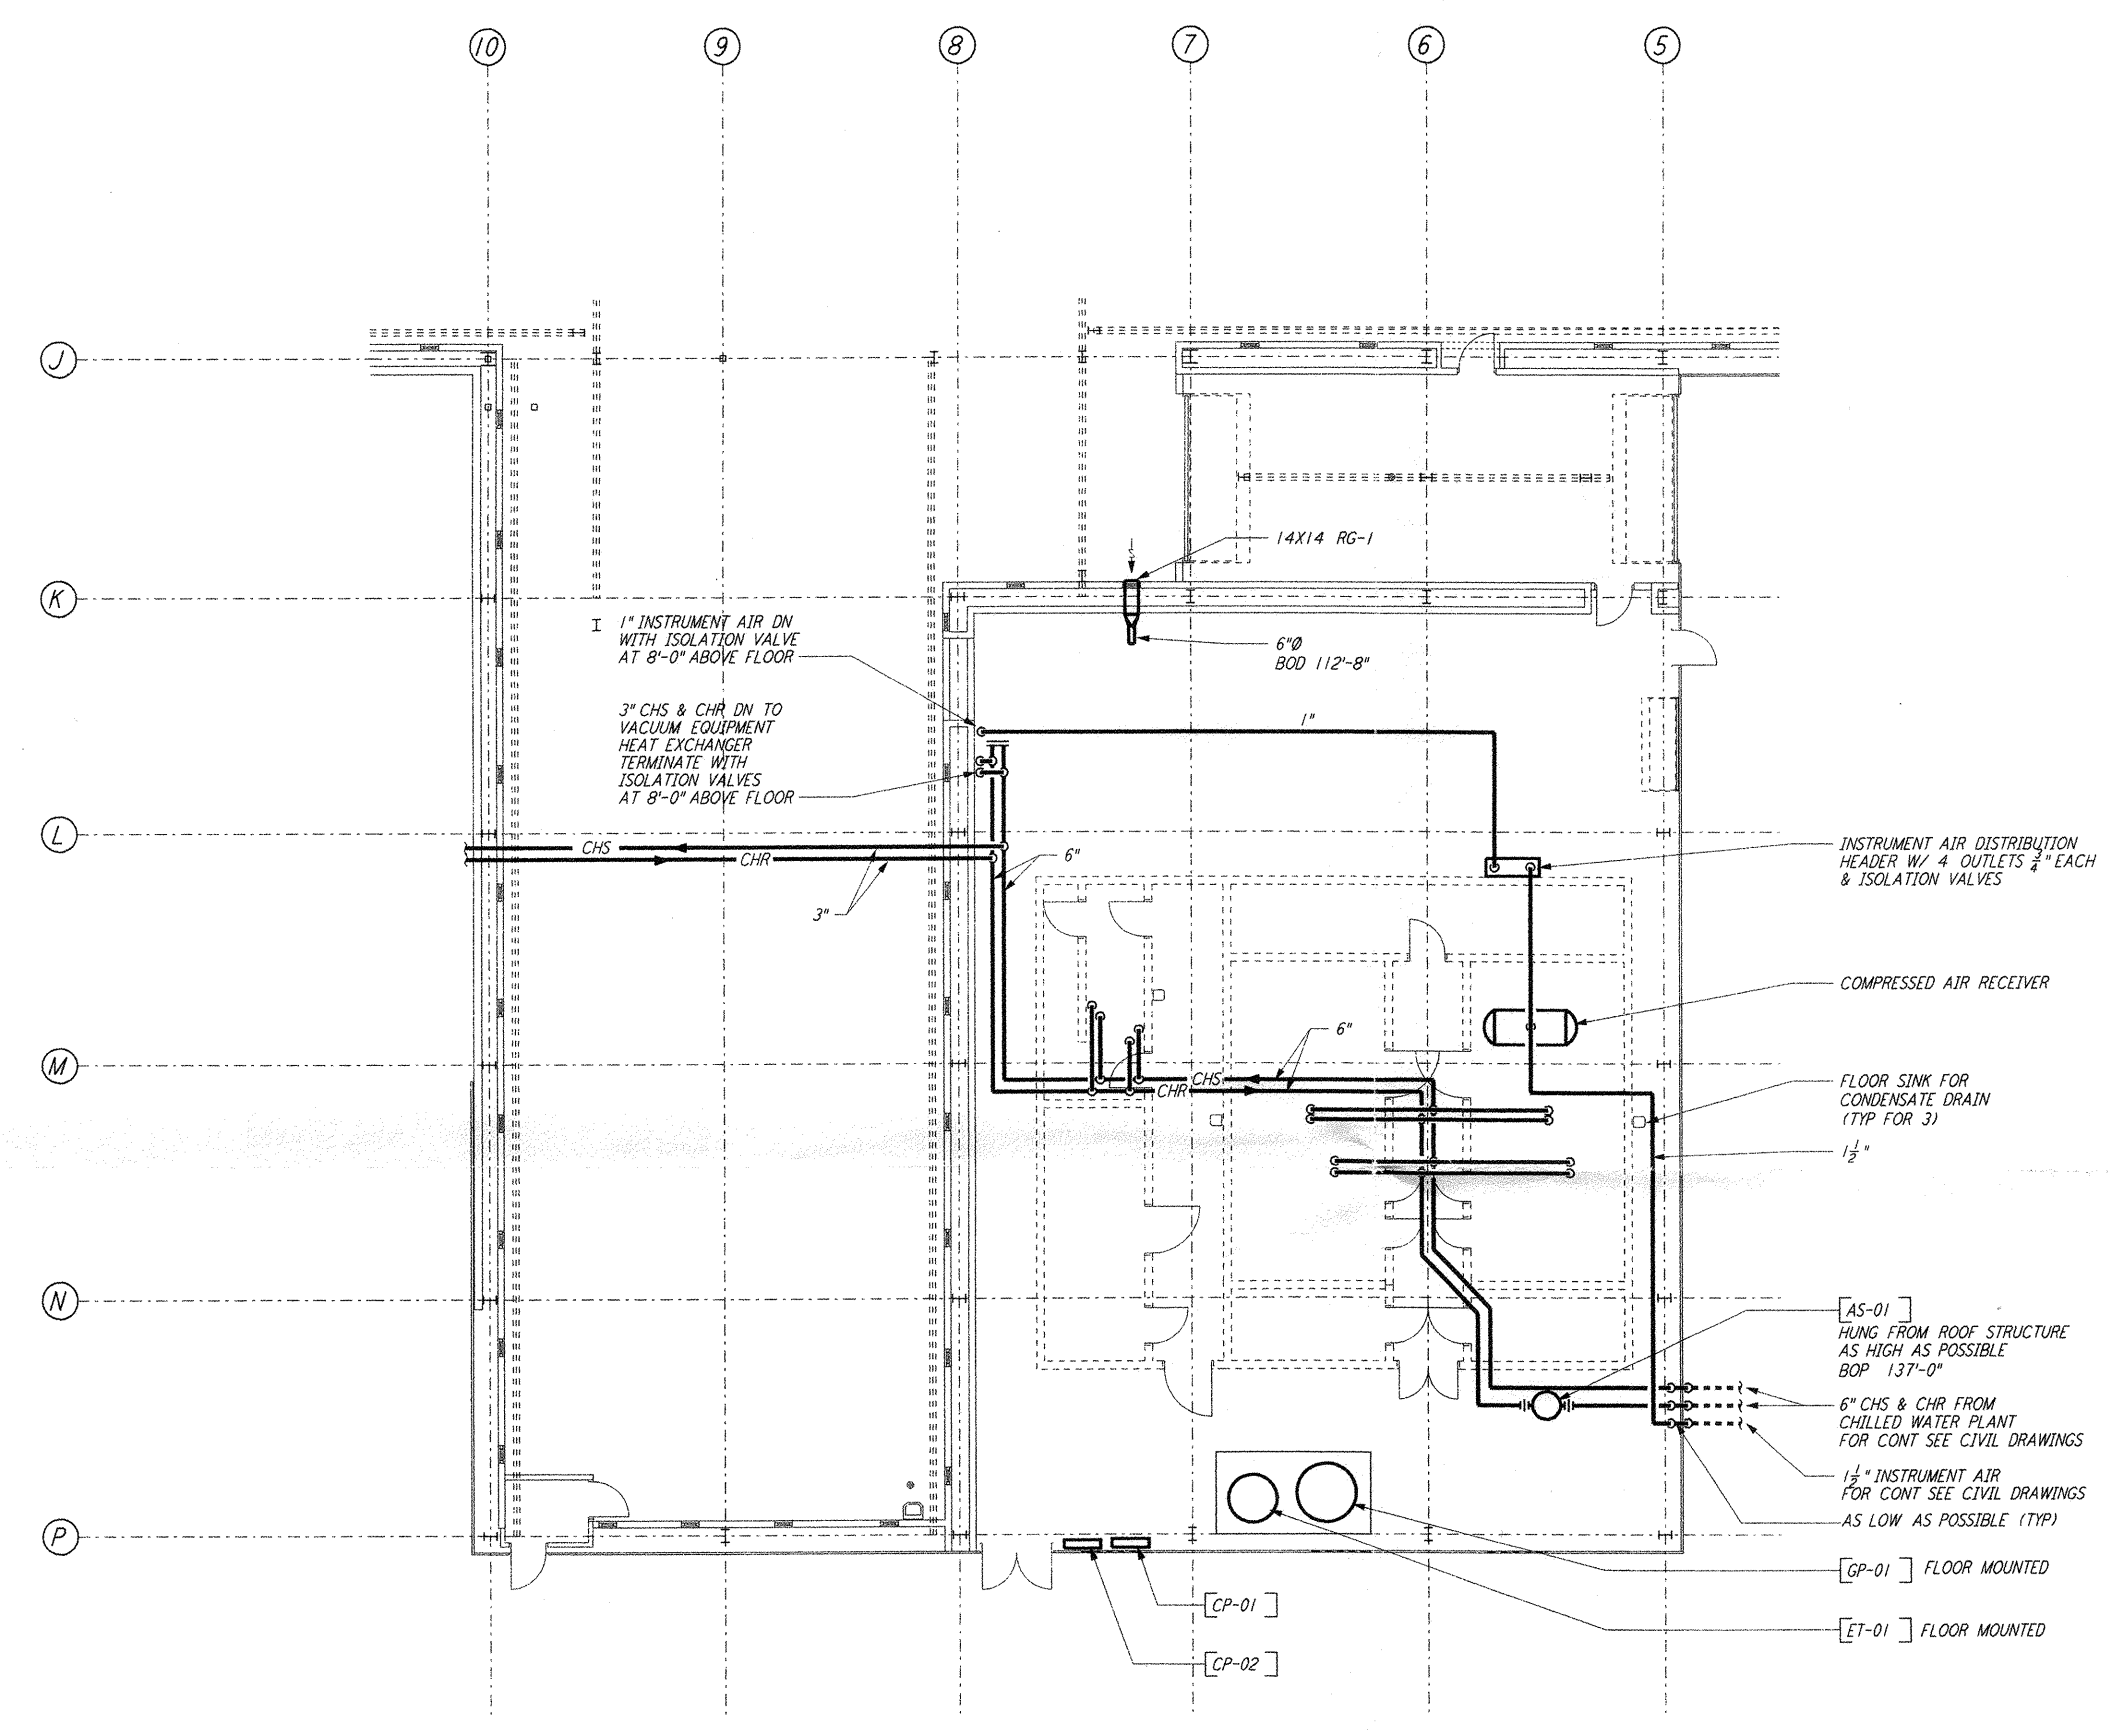

MECHANICAL ROOM PIPING PLAN
 $\frac{1}{8}'' = 1'-0''$

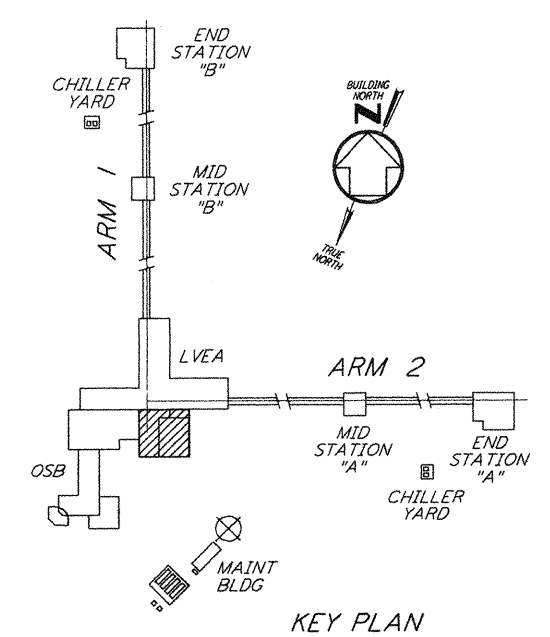

KEY PLAN
 $\frac{1}{8}'' = 1'-0''$

not be reproduced, copied, loaned, exhibited, or used in any other way, except by written consent from PARSONS to the borrower.

This document and the design it covers are the property of PARSONS. They are loaned only with the borrower's expressed written agreement that they will

NO.	DATE	BY	CHKD	ENGR	PROJ	DESCRIPTION
2	5-21-99	AO	AA	AA		ISSUED AS REVISED AS-BUILT
1	8-7-98	DJB	AA	AA	MDW	ISSUED FOR AS-BUILT

ISSUED FOR CONSTRUCTION	CLP	11-15-96
CHECKED	MN	10-25-96
ENGINEER	AA	1-23-96
PROJ	TDM	11-15-96

AS-BUILT DRAWINGS

100 WEST WALNUT STREET
 PASADENA, CALIFORNIA

CALIFORNIA INSTITUTE OF TECHNOLOGY
 MASSACHUSETTS INSTITUTE OF TECHNOLOGY

LIGO-D960973-02-0

LASER INTERFEROMETER
 GRAVITATIONAL-WAVE OBSERVATORY
 SITE NO. 2 - LIVINGSTON, LOUISIANA

TITLE	SCALE	CONTRACT NUMBER	PROJECT NUMBER
HVAC CORNER STATION LVEA & OSB MECHANICAL ROOM PIPING PLAN	AS NOTED	PP150969	8094
SHEET NUMBER		REVISIONS	
LA-H-117			