


- NOTES:**
- FOR LEGEND AND GENERAL NOTES SEE DWG LA-E-005.
 - TRANSFORMERS FEEDING THE CDSAC PANELS ARE TO BE K-13 RATED AND SHALL INCORPORATE AN INTERWINDING SHIELD, GROUNDED TO THE CASE GROUND. TRANSFORMERS ARE TO BE SUITABLE FOR OUTDOOR SERVICE.
 - CDSAC PANELS SHALL HAVE 200% RATED NEUTRAL BUSES.
 - GROUND CONDUCTOR FROM TRANSFORMER NEUTRAL/CASE BOND JUNCTION TO GROUND GRID SHALL BE NO LONGER THAN 4 FT.
 - ALL CIRCUIT BREAKERS SHALL BE PROVIDED WITH LOCKING/LOCKABLE ACCESSORIES TO ENSURE THAT CIRCUITS ARE ENERGIZED BY AUTHORIZED PERSONNEL ONLY.
 - DISTRIBUTION AND LIGHTING PANELS SHALL BE FURNISHED WITH LOCKABLE DOORS. CIRCUIT BREAKERS SHALL BE PROVIDED WITH LOCKING/LOCKABLE ACCESSORIES TO ENSURE THAT CIRCUITS ARE ENERGIZED BY AUTHORIZED PERSONNEL ONLY.

**SWITCHBOARD L-CS-107-SB-01
SQUARE D CLASS 2741**

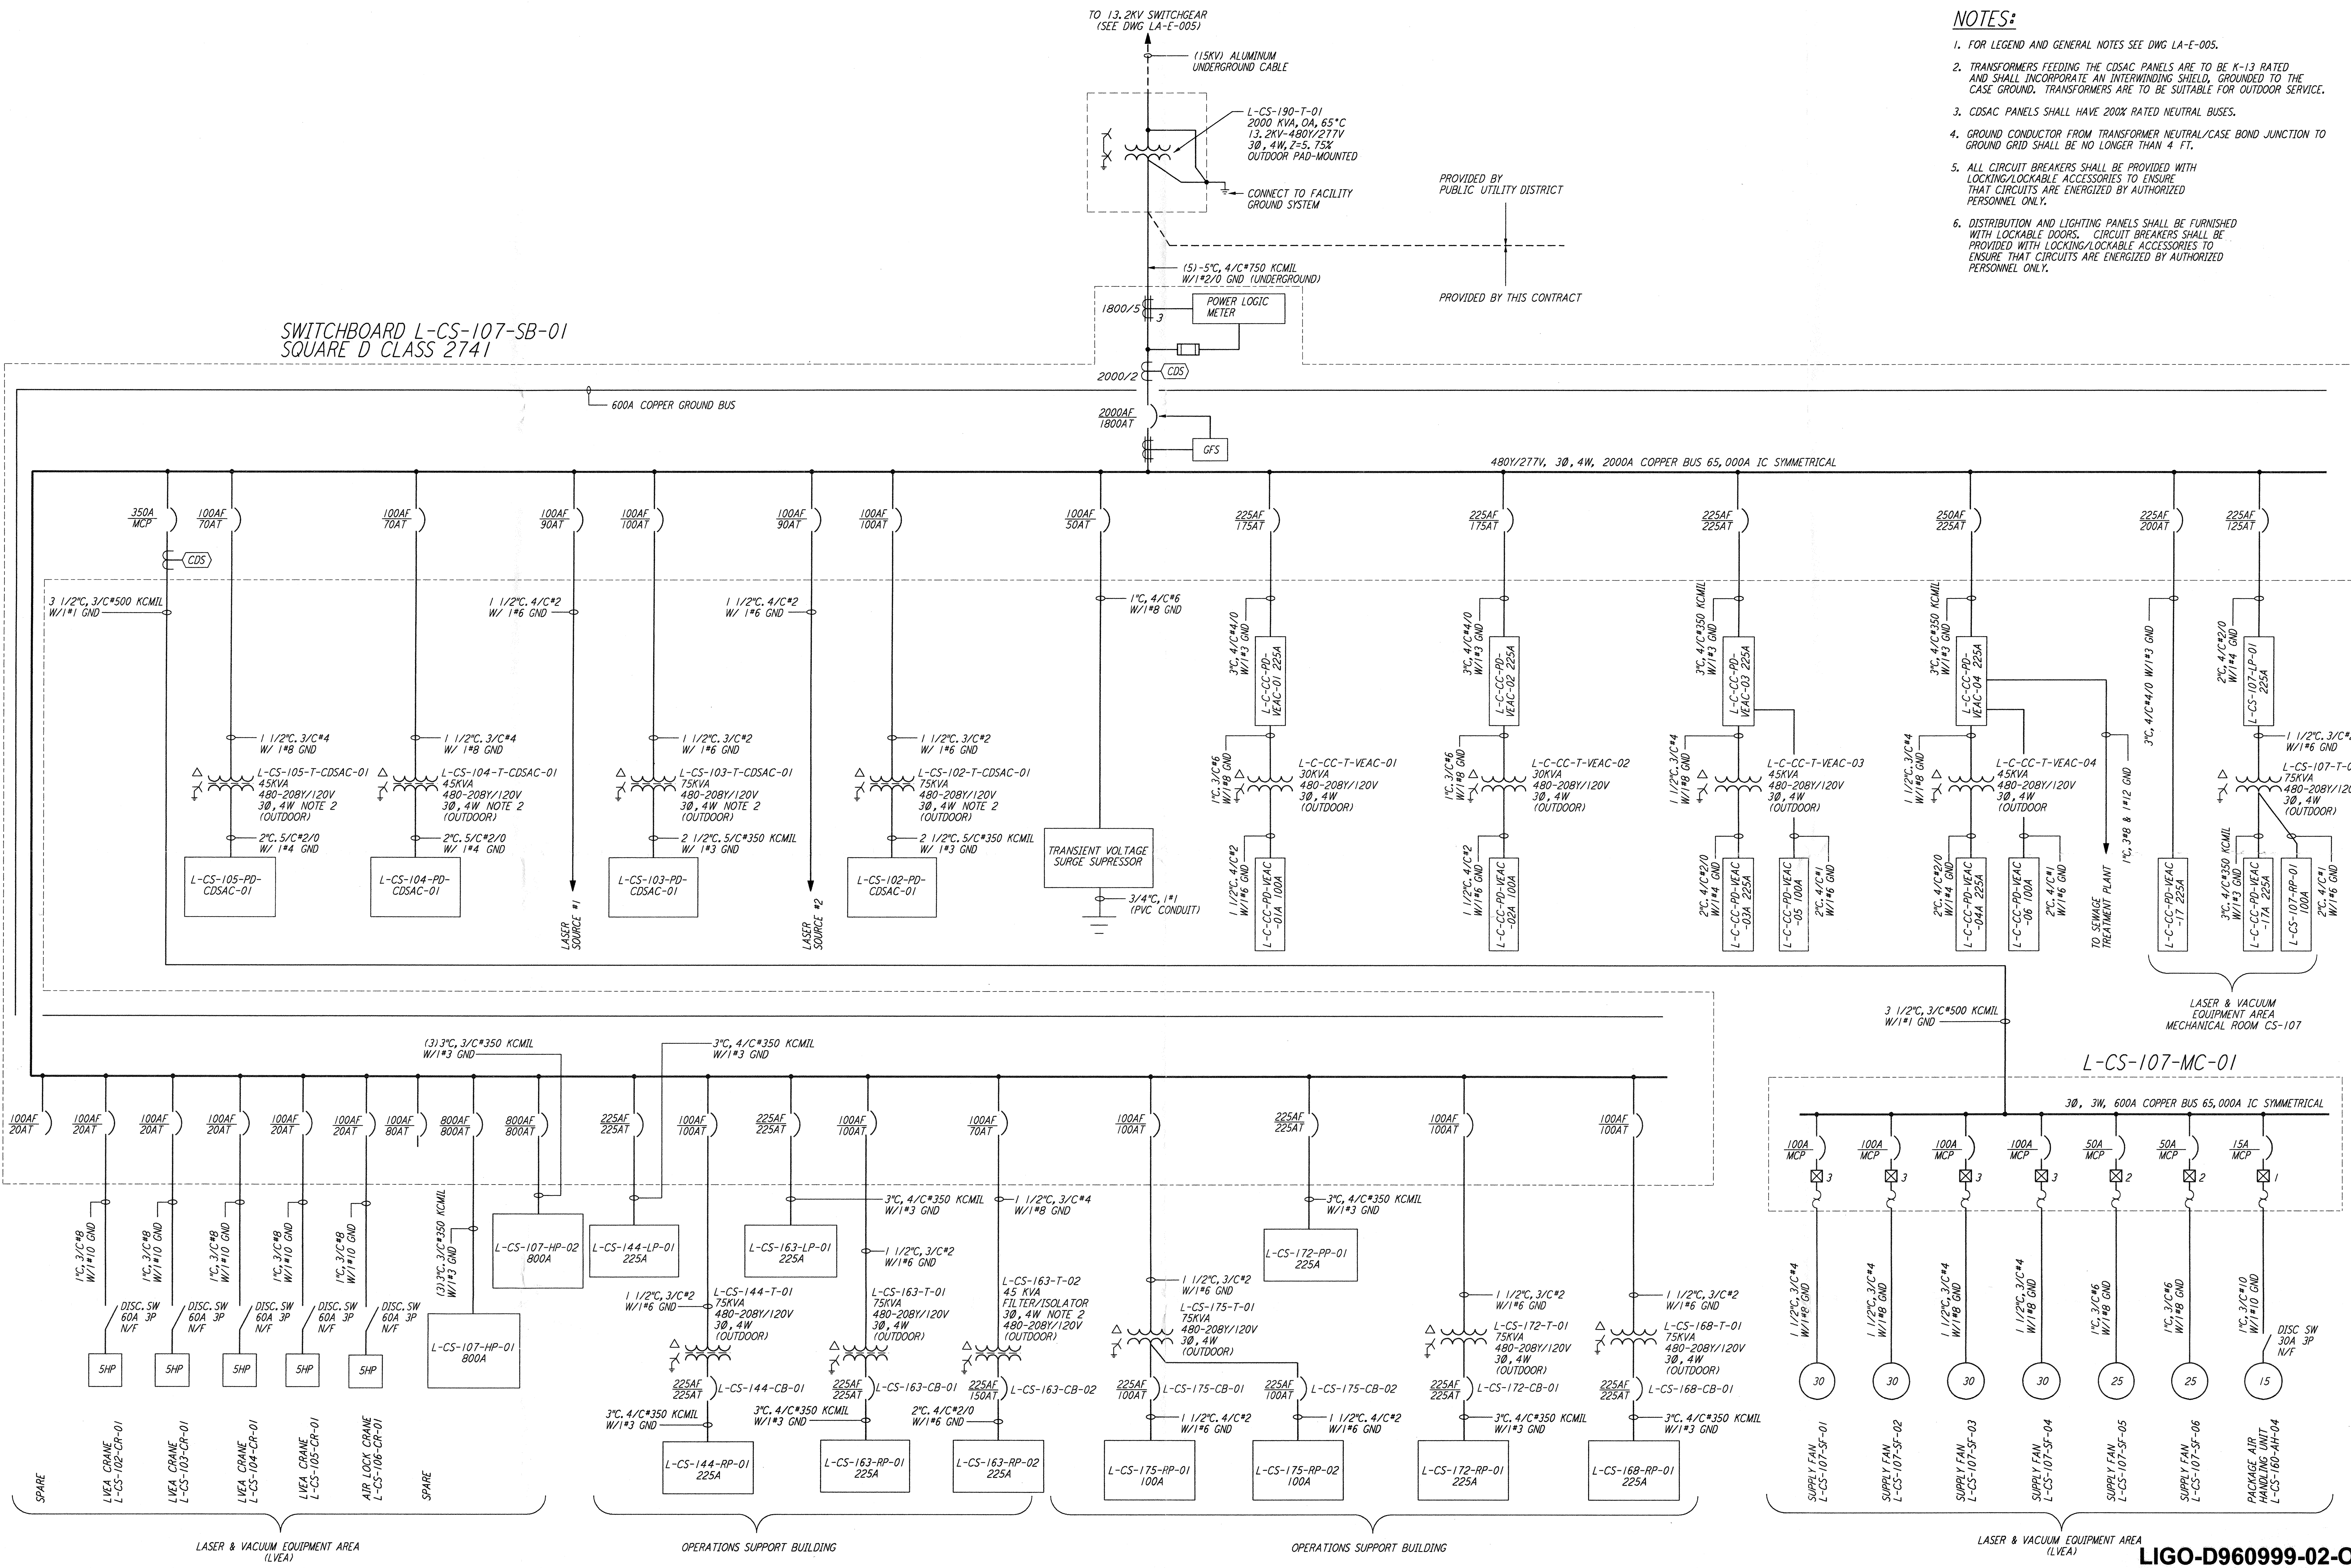

This document and the design it covers are the property of PARSONS. They are loaned only with the borrower's expressed written agreement that they will not be reproduced, copied, loaned, exhibited, or used in any other way, except by written consent from PARSONS to the borrower.

DRAWING NO.	DESCRIPTION	NO.	DATE	BY	CHKD	ENGR	PROJ	DESCRIPTION
2	5-21-99	AO						ISSUED AS REVISED AS-BUILT
1	8-7-98	JE		AK	AG	MDW		ISSUED FOR AS-BUILT

ISSUED FOR CONSTRUCTION			
DRAWN	M. M.	11-15-96	
CHECKED	JCL	7-24-96	
ENGINEER	KCR	10-25-96	
PROJ	T. D. M.	11-15-96	
AS-BUILT DRAWINGS			

PARSONS
100 WEST WALNUT STREET
PASADENA, CALIFORNIA

LIGO
CALIFORNIA INSTITUTE OF TECHNOLOGY
MASSACHUSETTS INSTITUTE OF TECHNOLOGY

LIGO-D960999-02-0
LASER INTERFEROMETER
GRAVITATIONAL-WAVE OBSERVATORY
SITE NO. 2 - LIVINGSTON, LOUISIANA

TITLE	SCALE	CONTRACT NUMBER	PROJECT NUMBER
ELECTRICAL CORNER STATION SINGLE LINE DIAGRAM	NONE	PP150969	8094
SHEET NUMBER		REVISIONS	
LA-E-006			

5/21/99 3:16:33 PM C:\PLOT\JOB\33-13682.qpf 520855 K:\13682\ee\lao006a.prf