

 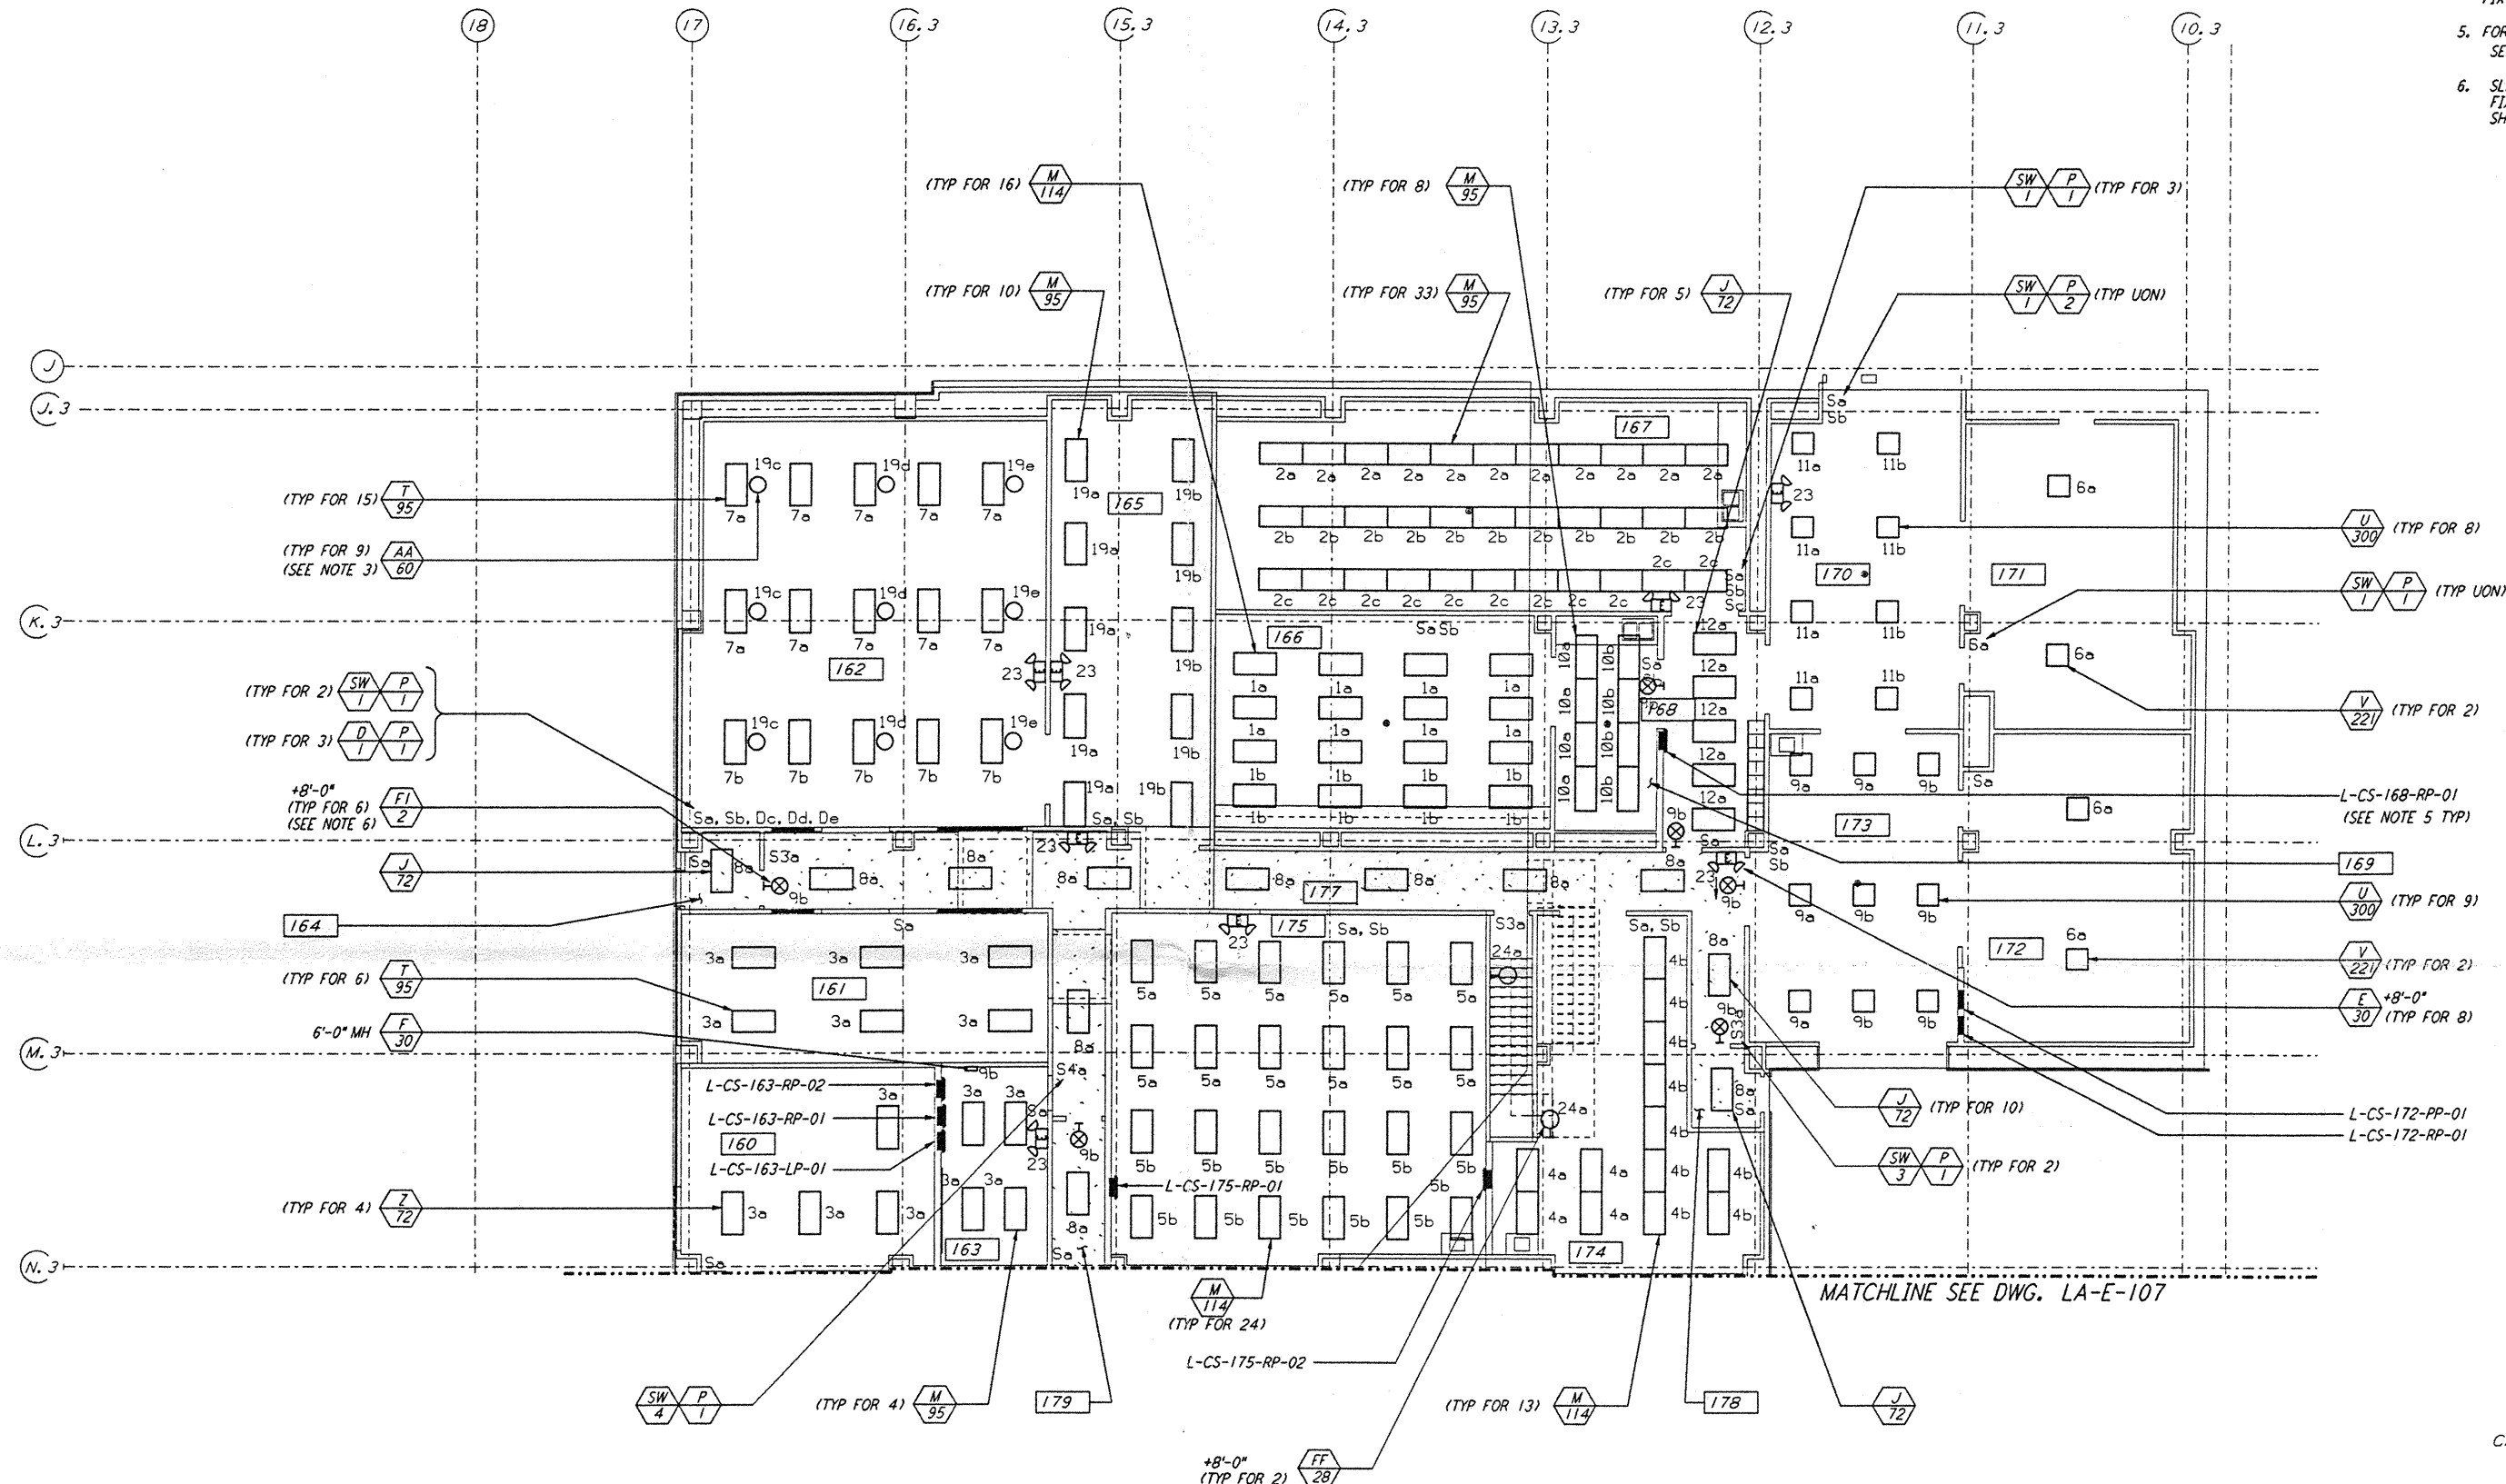
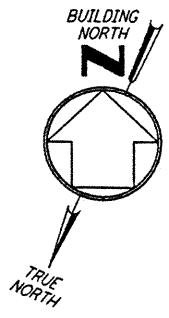


NOTES:

- FOR NOTES AND REFERENCE DRAWINGS SEE DWG. LA-E-107.
- ALL LIGHTING CIRCUITS SHOWN ON THIS DRAWING ARE FROM PANEL L-CS-163-LP-01 UNLESS NOTED OTHERWISE.
- CIRCUIT SHOWN FEEDING THESE LIGHTING FIXTURES IS FROM L-CS-163-RP-01.
- CIRCUIT SHOWN FEEDING THESE LIGHTING FIXTURES IS FROM L-CS-168-RP-01.
- FOR ALL PANEL FEEDER CONDUIT AND WIRE SIZES SEE SINGLE LINE DIAGRAM DWG LA-E-006.
- SLAVE UNIT, CIRCUIT SHOWN FEEDING THESE FIXTURES IS FROM L-CS-144-LP-01 VIA TYPE F-30 FIXTURE SHOWN ON THIS DWG.




MATCHLINE SEE DWG. LA-E-107

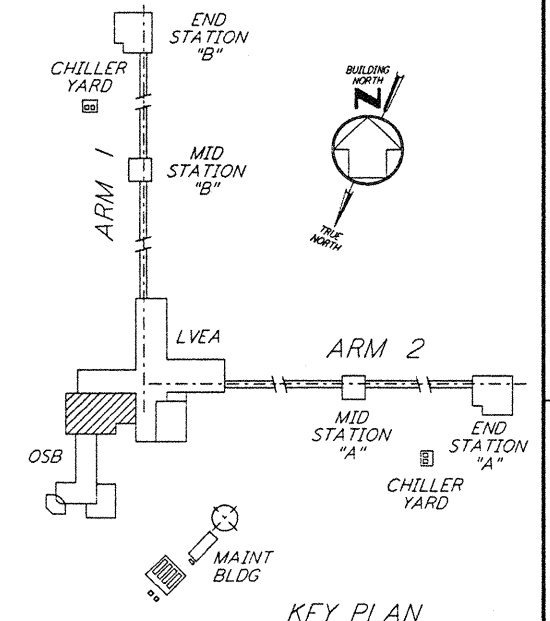

This document and the design it covers are the property of PARSONS. They are loaned only with the borrower's expressed written agreement that they will not be reproduced, copied, loaned, exhibited, or used in any other way, except by written consent from PARSONS to the borrower.

NO.	DATE	BY	CHKD	ENGR	PROJ	DESCRIPTION

ISSUED FOR CONSTRUCTION	
DRAWN	M. M. 11-15-96
CHECKED	JCL 7-24-96
ENGINEER	KZL 10-25-96
PROJ	52029 11/15/96

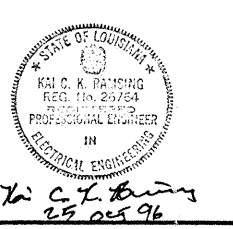

PARSONS
 100 WEST WALNUT STREET
 PASADENA, CALIFORNIA

LIGO
 CALIFORNIA INSTITUTE OF TECHNOLOGY
 MASSACHUSETTS INSTITUTE OF TECHNOLOGY

LASER INTERFEROMETER GRAVITATIONAL-WAVE OBSERVATORY SITE NO. 2 - LIVINGSTON, LOUISIANA			
TITLE	SCALE	CONTRACT NUMBER	PROJECT NUMBER
ELECTRICAL CORNER STATION OSB LAB AREA LIGHTING PLAN	AS NOTED	PP150969	8094
SHEET NUMBER		REVISION	
LA-E-108			

I:\LIGO\SITE2\EE\LA-E-108.DWG

I:\LIGO\SITE2\EE\LA-E-108.DWG