


WASTE AND VENT RISER DIAGRAM

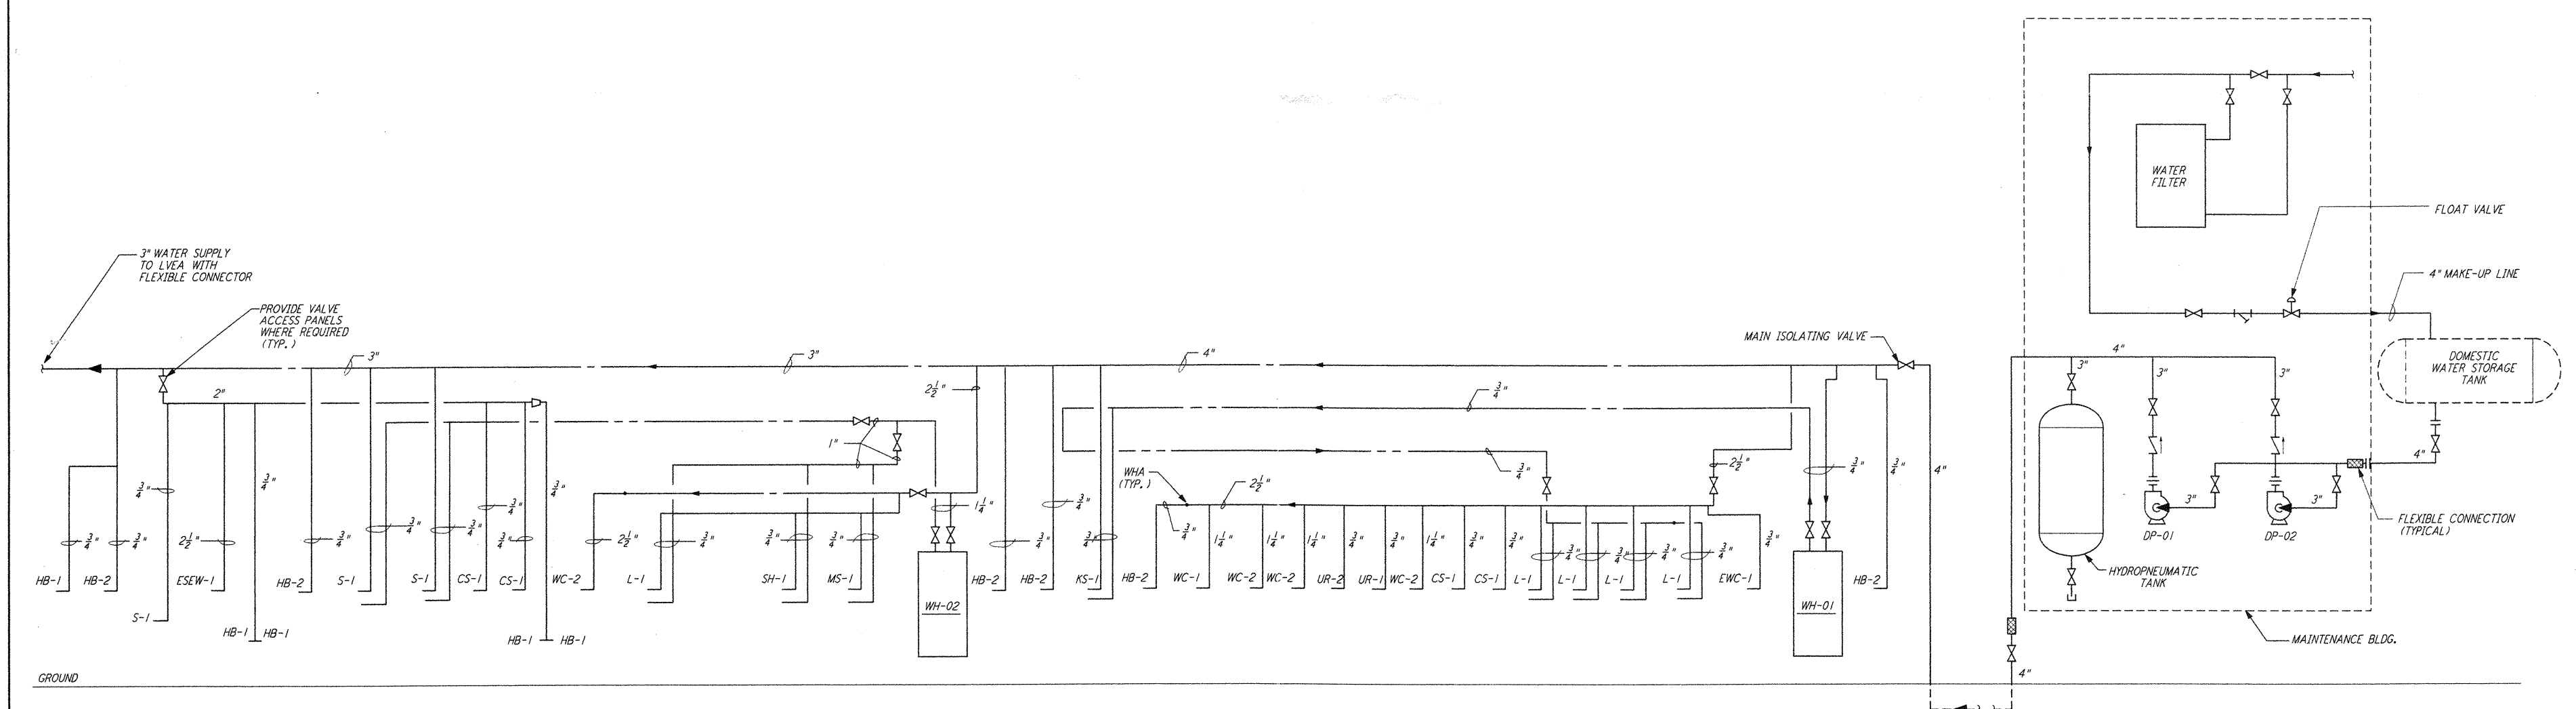


HOT AND COLD WATER RISER DIAGRAM

This document and the design it covers are the property of PARSONS. They are loaned only with the borrower's expressed written agreement that they will not be reproduced, copied, loaned, exhibited, or used in any other way, except by written consent from PARSONS to the borrower.

NO.	DATE	BY	CHKD	ENGR	PROJ	DESCRIPTION
2	8-7-98	DJB	AA	AA	TDM	ISSUED FOR AS-BUILT
1	3-20-97	WJK	AA	AA	TDM	REVISED PLUMBING RISER DIAGRAMS

ISSUED FOR CONSTRUCTION
 DRAWN DC 11-15-96
 CHECKED MC 10-25-96
 ENGINEER AA 10-25-96
 PROJ TDM 11-15-96
AS-BUILT DRAWINGS

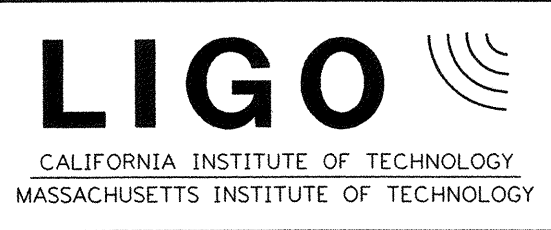

LIGO-D961051-02-O			
LASER INTERFEROMETER GRAVITATIONAL-WAVE OBSERVATORY SITE NO. 2 - LIVINGSTON, LOUISIANA			
TITLE	PLUMBING CORNER STATION RISER DIAGRAM	CONTRACT NUMBER	PP150969
SHEET NUMBER	LA-P-131	PROJECT NUMBER	8094
REVISIONS		DATE	

5

4

3

2

1

LIGOLAF.BOR

P:\Aug 14 18:56:07 1998 C:\PLOT\LDUE\03-98\B2\0CF 52895 KLV2882.mpl131.szd