



- NOTES:**
- 1.) FOR GENERAL NOTES & LEGEND SEE PSI DWG. #V049-3-001 SHT. 1.
 - 2.) FOR LIST OF CIVIL CONTRACTORS REFERENCE DWGS. WITH CURRENT REVISIONS SEE PSI DWG. #V049-3-001 SHT. 2.
 - 3.) GROUND GRID IS BY OTHERS.
 - 4.) TIE GROUNDING CONDUCTOR TO EXISTING GROUND GRID. SEE PARSONS DWG. #VA-E-202.
 - 5.) GROUND VENT PIPE SUPPORT TO EXISTING GROUND GRID. SEE PARSONS DWG. #VA-E-202.

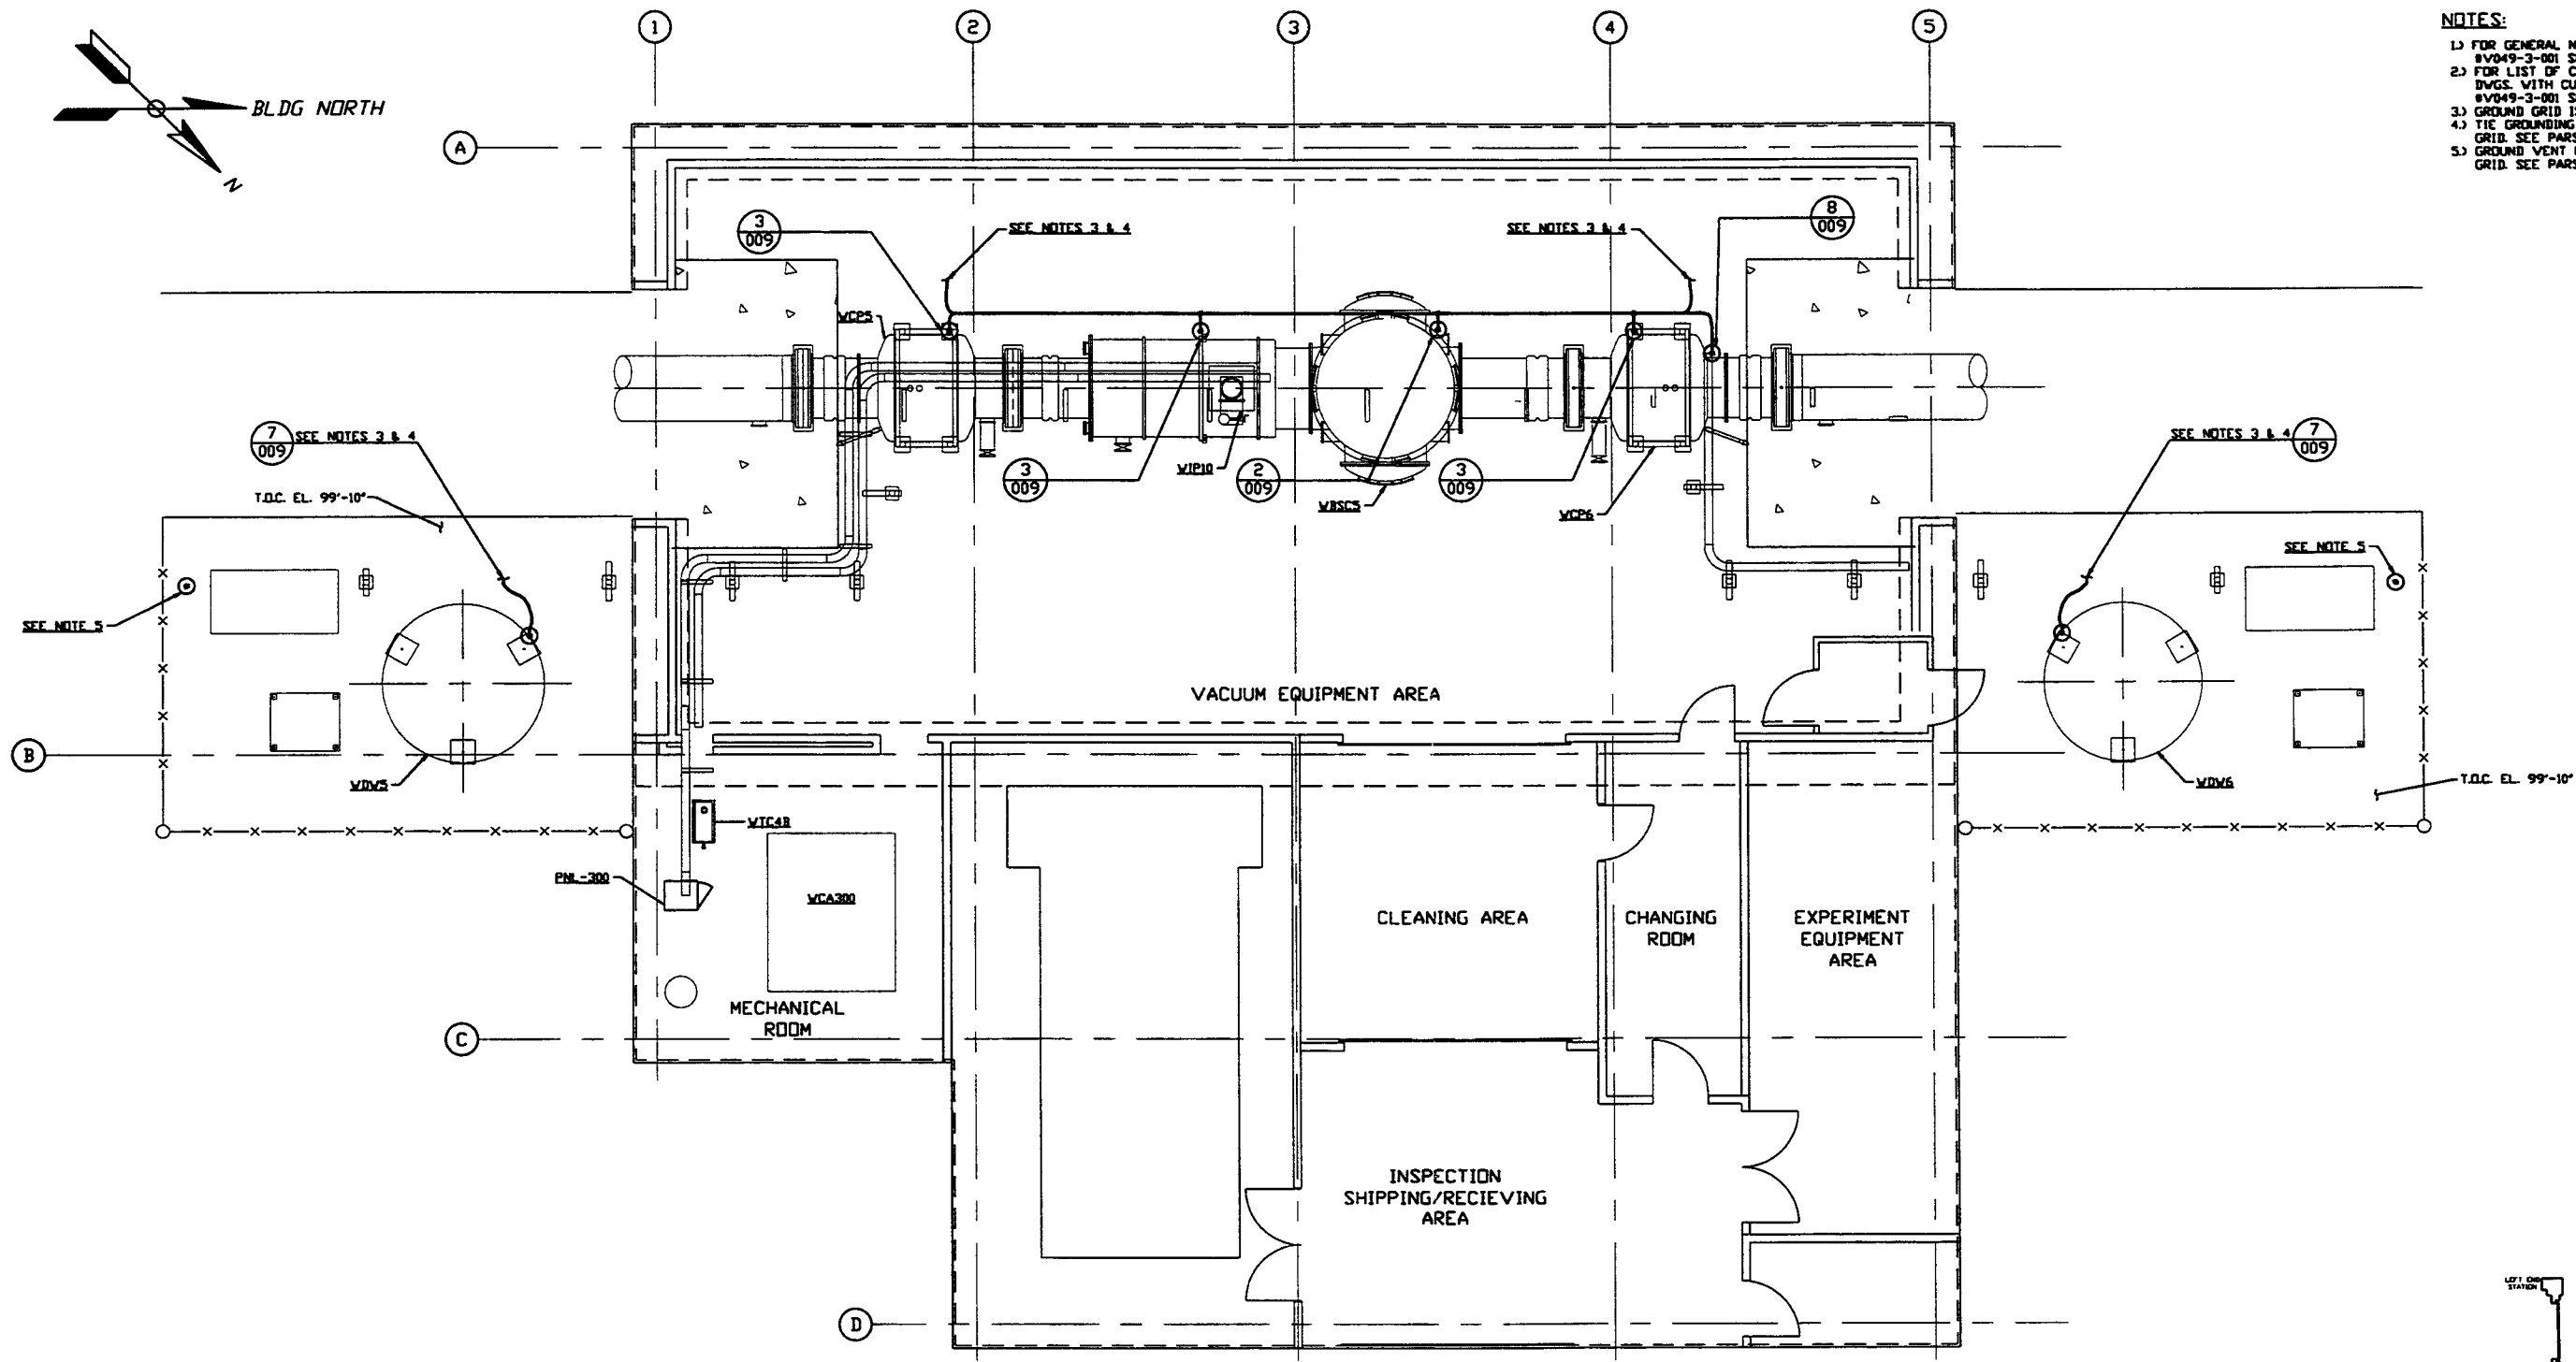

RIGHT MID STATION PLAN @ EL. 100'-0"

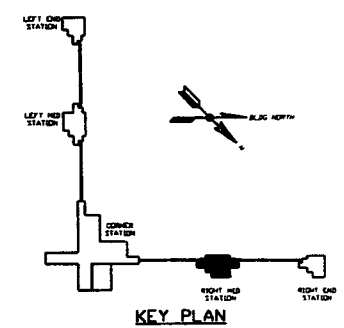

<p>PROPRIETARY AND CONFIDENTIAL</p> <p>THIS DOCUMENT CONTAINS PROPRIETARY INFORMATION BELONGING TO PROCESS SYSTEMS INTERNATIONAL, INC. OR ITS AFFILIATED COMPANIES AND SHALL BE USED ONLY FOR THE PURPOSE FOR WHICH IT WAS SUPPLIED. IT SHALL NOT BE COPIED, REPRODUCED OR OTHERWISE USED, NOR SHALL SUCH INFORMATION BE FURNISHED IN WHOLE OR IN PART TO OTHERS EXCEPT IN ACCORDANCE WITH THE TERMS OF ANY AGREEMENT UNDER WHICH IT WAS SUPPLIED OR WITH THE WRITTEN CONSENT OF PROCESS SYSTEMS INTERNATIONAL, INC. AND SHALL BE RETURNED UPON REQUEST.</p>		<p>UNLESS OTHERWISE SPECIFIED DIMENSIONS ARE IN INCHES</p> <p>TOLERANCES: FRACTIONAL & DECIMALS - AS SHOWN HOLE DRILLING 1/8" - 3/4" BORE ± .015" TWO PLACE DECIMAL ± .005" THREE PLACE DECIMAL ± .002" FINISHED SURFACE DIM. BREAK CORNERS TO REMOVE ALL BURRS</p>		<p>1 ISSUE FOR CONSTRUCTION</p>		<p>05.12.97 0480</p>		<p>PROCESS SYSTEMS INTERNATIONAL, INC. 20 WALKUP DR. WESTBOROUGH, MASSACHUSETTS 01581 USA</p>	
V049-3-302	CABLE TRAY PLAN RIGHT MID STATION							<p>GROUNDING PLAN LIGO VACUUM EQUIPMENT WASHINGTON SITE RIGHT MID STATION</p>	
V049-3-009	GROUNDING DETAILS								
V049-3-002	OVERALL SITE PLAN WASHINGTON								
V049-3-001	GENERAL NOTES & LEGEND								
DWG. NO.	DESCRIPTION	DWG. NO.	DESCRIPTION	ISSUE DESCRIPTION	REV	CHKD	DRWN	DATE	DESP
	REFERENCE DRAWINGS								
<p>DO NOT SCALE THIS DRAWING</p>		<p>USED ON:</p>		<p>REV</p>		<p>ISSUE DESCRIPTION</p>		<p>SCALE 3/16" = 1' - 0"</p>	
<p>NEXT ASS'Y:</p>		<p>REB DMcV</p>		<p>REV</p>		<p>CHKD DRWN</p>		<p>DATE</p>	
<p>8</p>		<p>7</p>		<p>6</p>		<p>5</p>		<p>4</p>	
<p>3</p>		<p>2</p>		<p>1</p>		<p>1 OF 1</p>		<p>LIGO-D961755-01-V</p>	