



SECTION A  
SCALE: 1/4" = 1'-0"


- CONSTRUCTION NOTES
- 1 SUSPEND SEPARATION CURTAIN SUPPORT STEEL FROM ROOF STEEL. OPTION: ATTACH CURTAIN SUPPORT STEEL TO EXISTING SUPPORT STEEL AT  $\Delta$ .
  - 2 TRAPEZE SUPPORT STEEL TO AVOID INTERFERENCE WITH AHU'S AND DUCT.
  - 3 SIDE CURTAINS LENGTH TO FLOOR.
  - 4 SHORT CURTAINS LENGTH TO TOP OF EQUIPMENT RACKS.
  - 5 CURTAIN AND STEEL SHOWN IS ON WAREHOUSE SIDE OF DOOR.

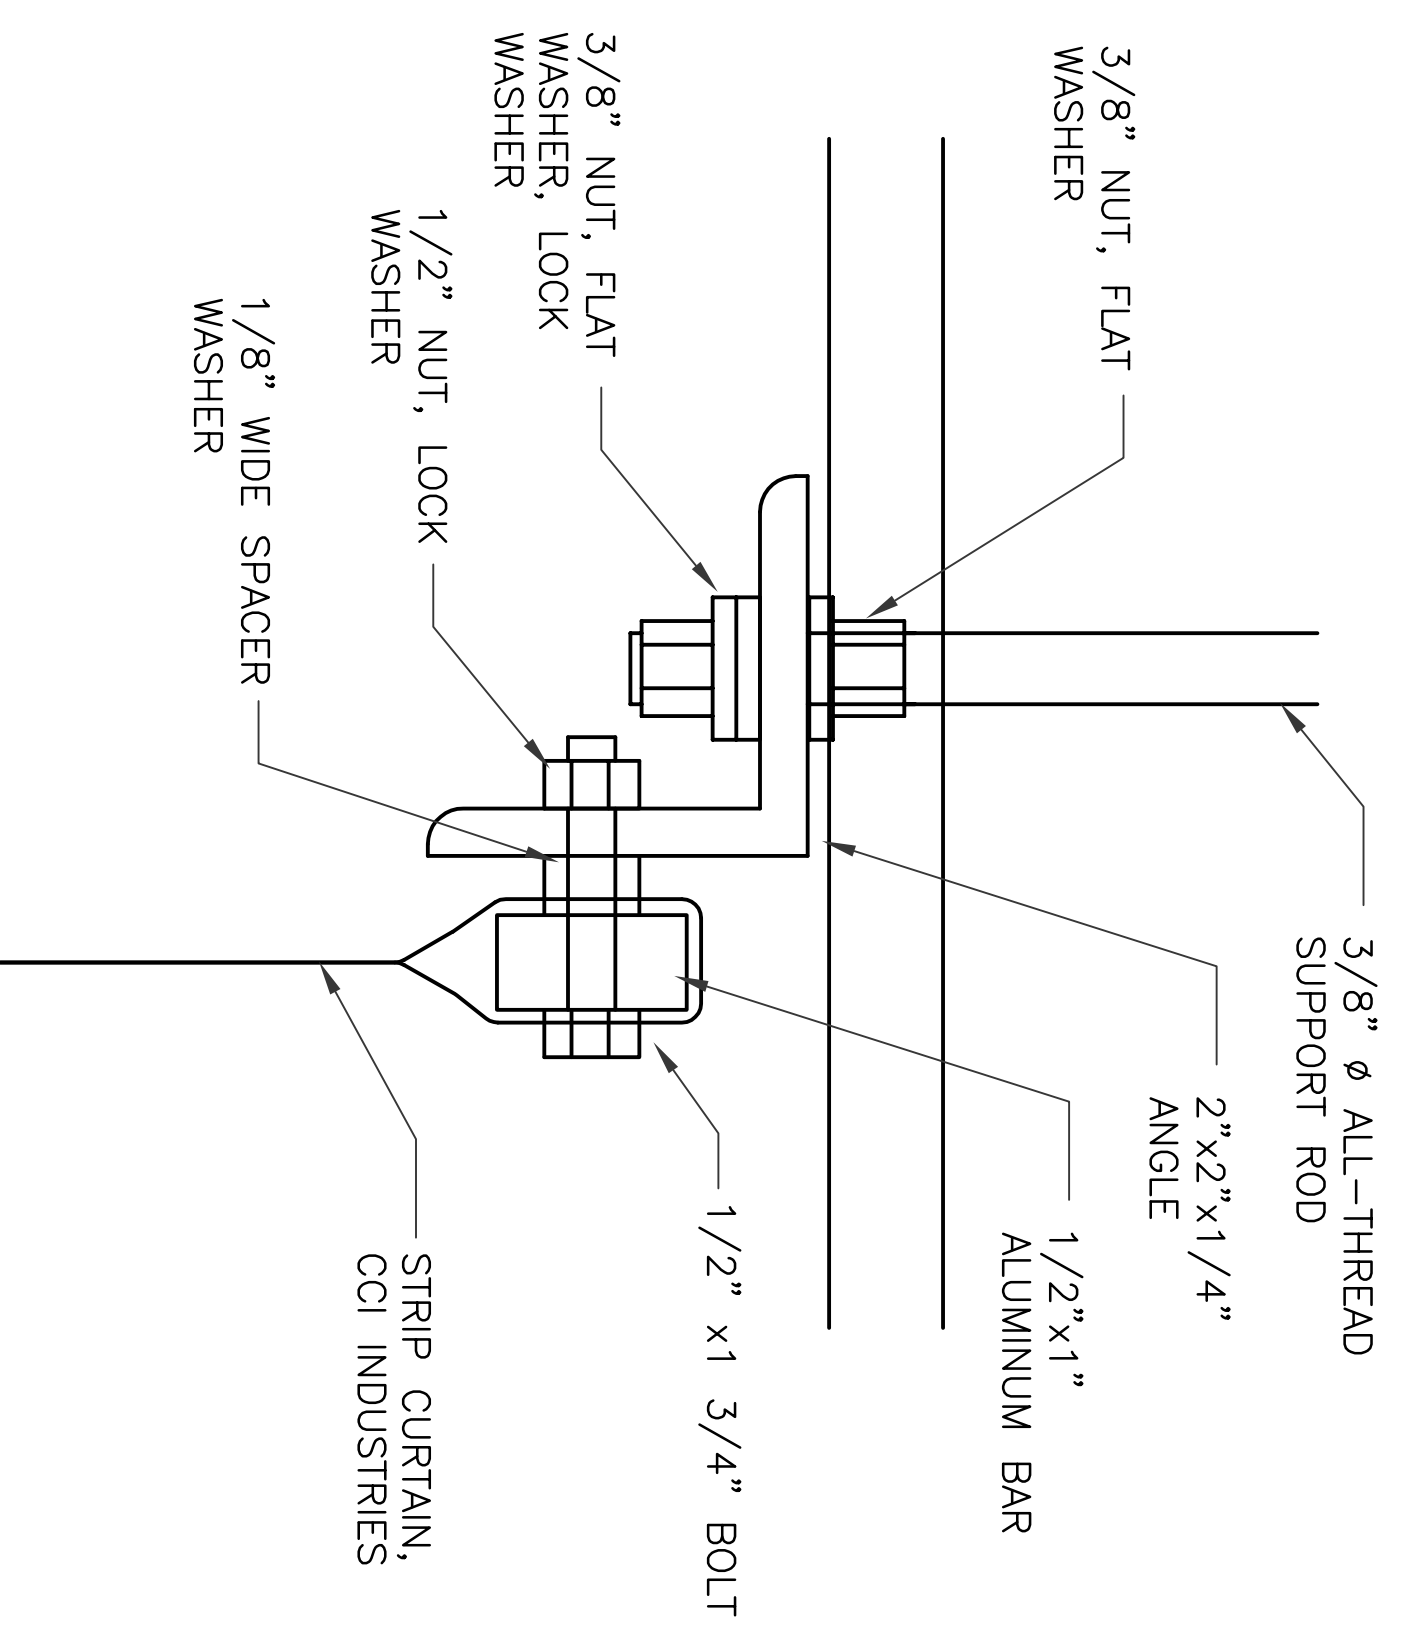

2  
CURTAIN ATTACHMENT  
SCALE: 1" = 1'-0"

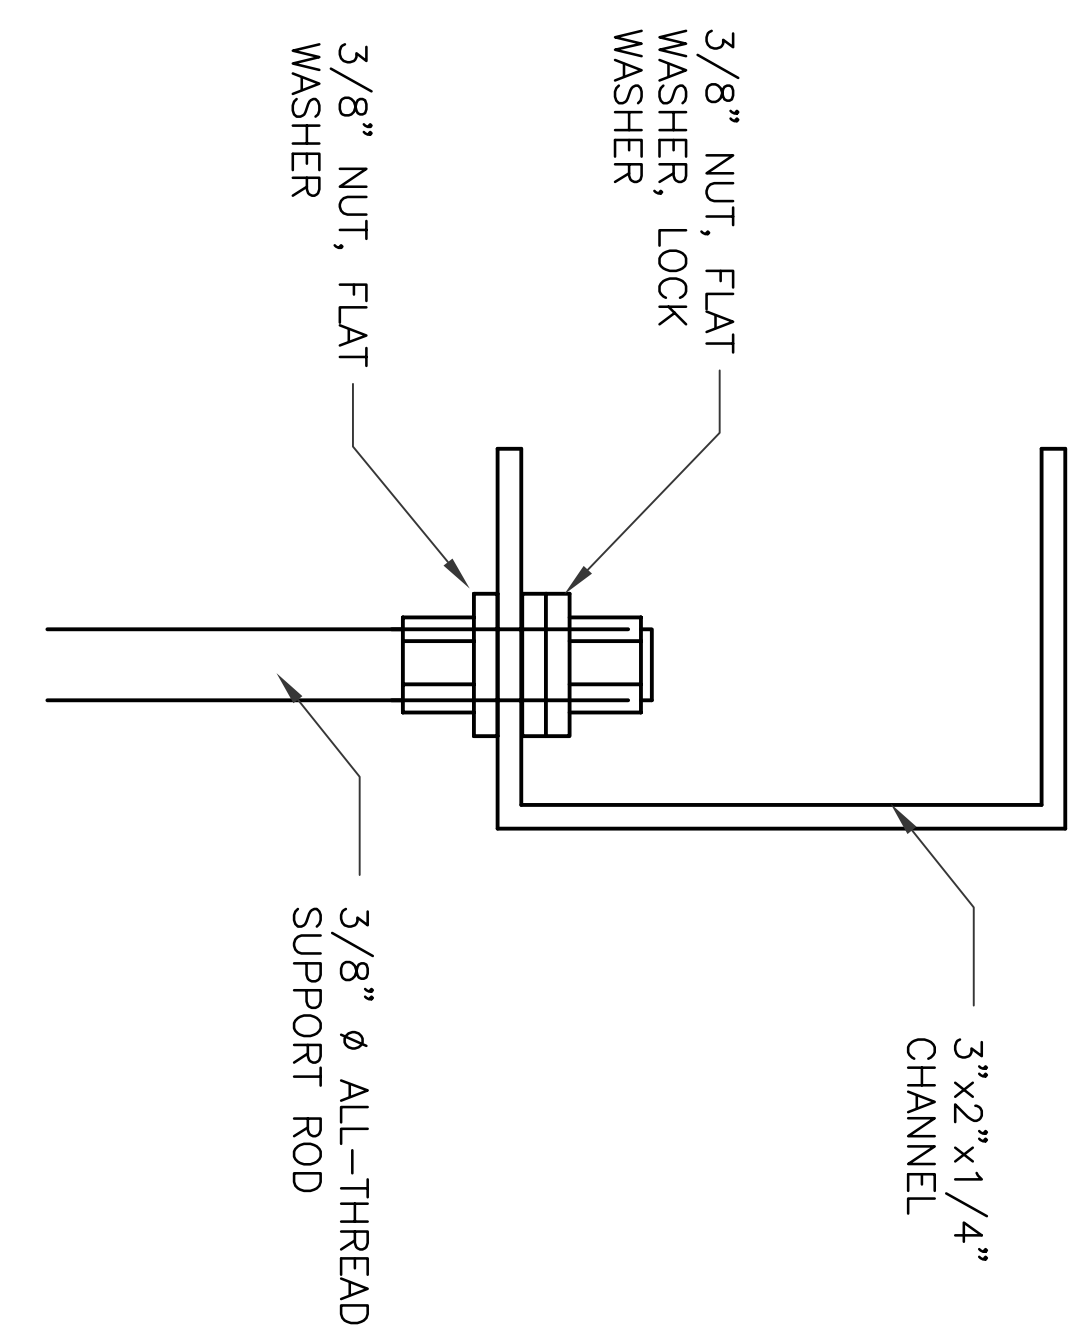

1  
ROD SUPPORT  
SCALE: 1" = 1'-0"

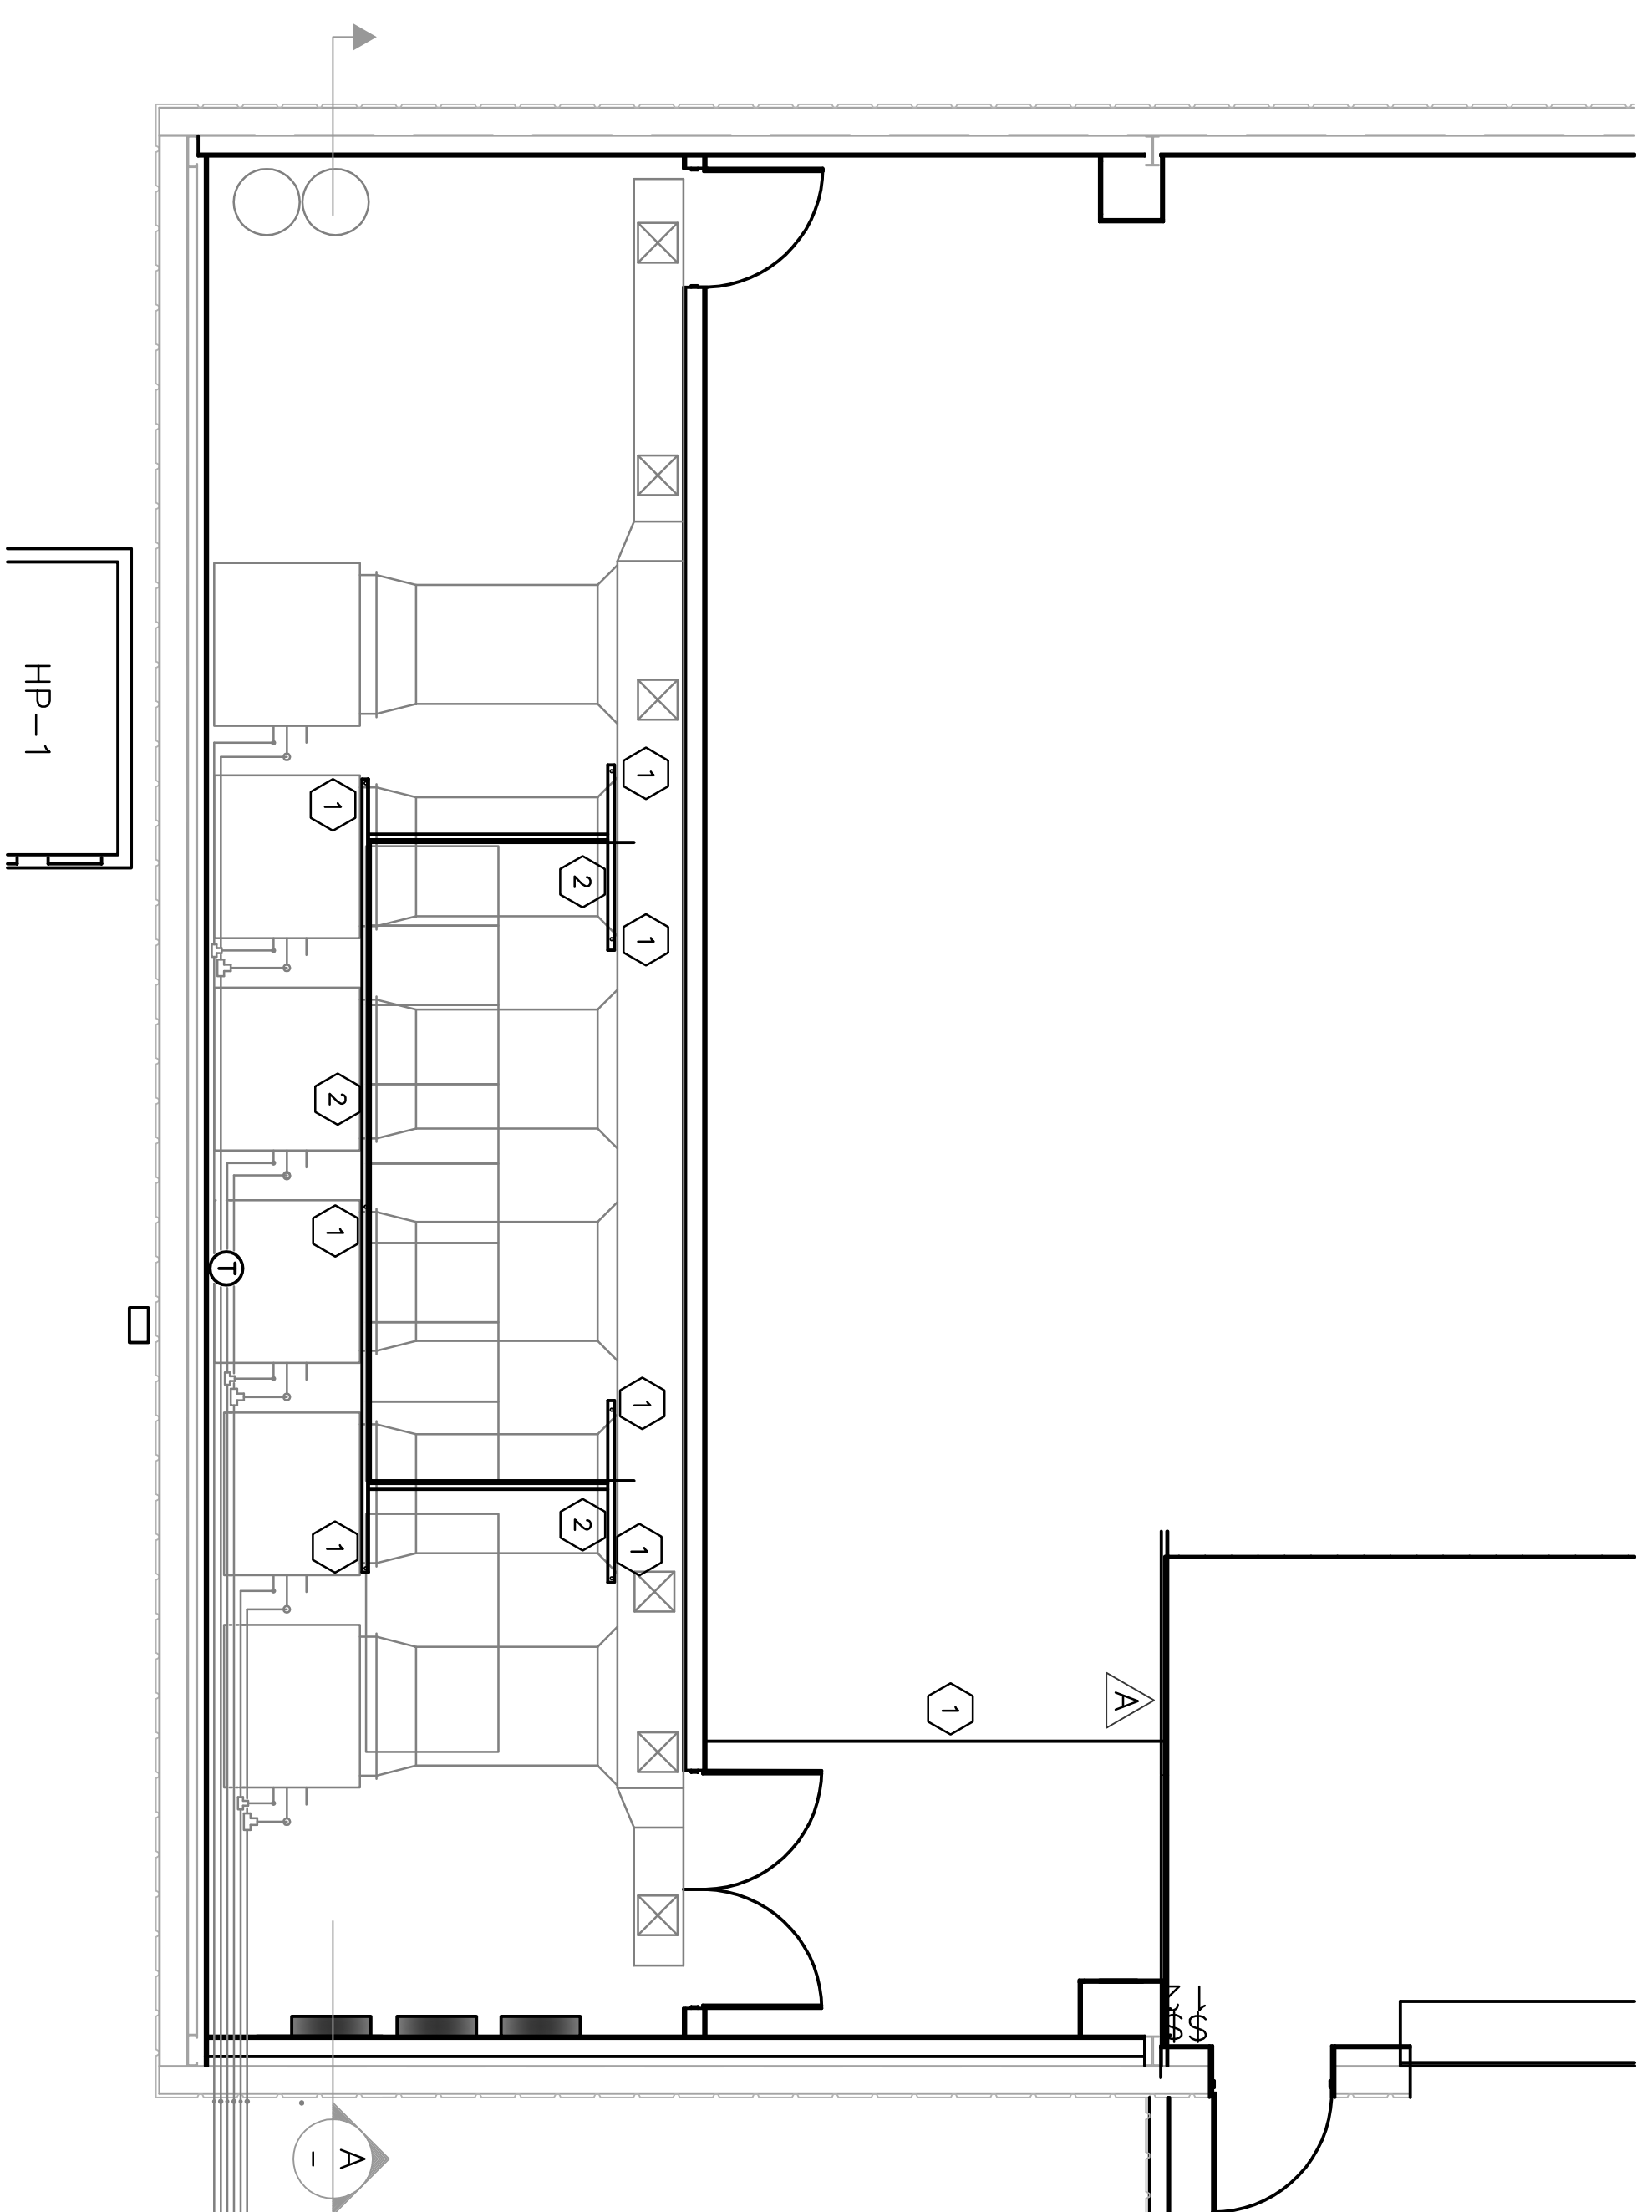

HVAC PLAN  
SCALE: 1/4" = 1'-0"

