


1 FC TUBE ENCLOSURE A - FOUNDATION PLAN
S100 1/8" = 1'-0"

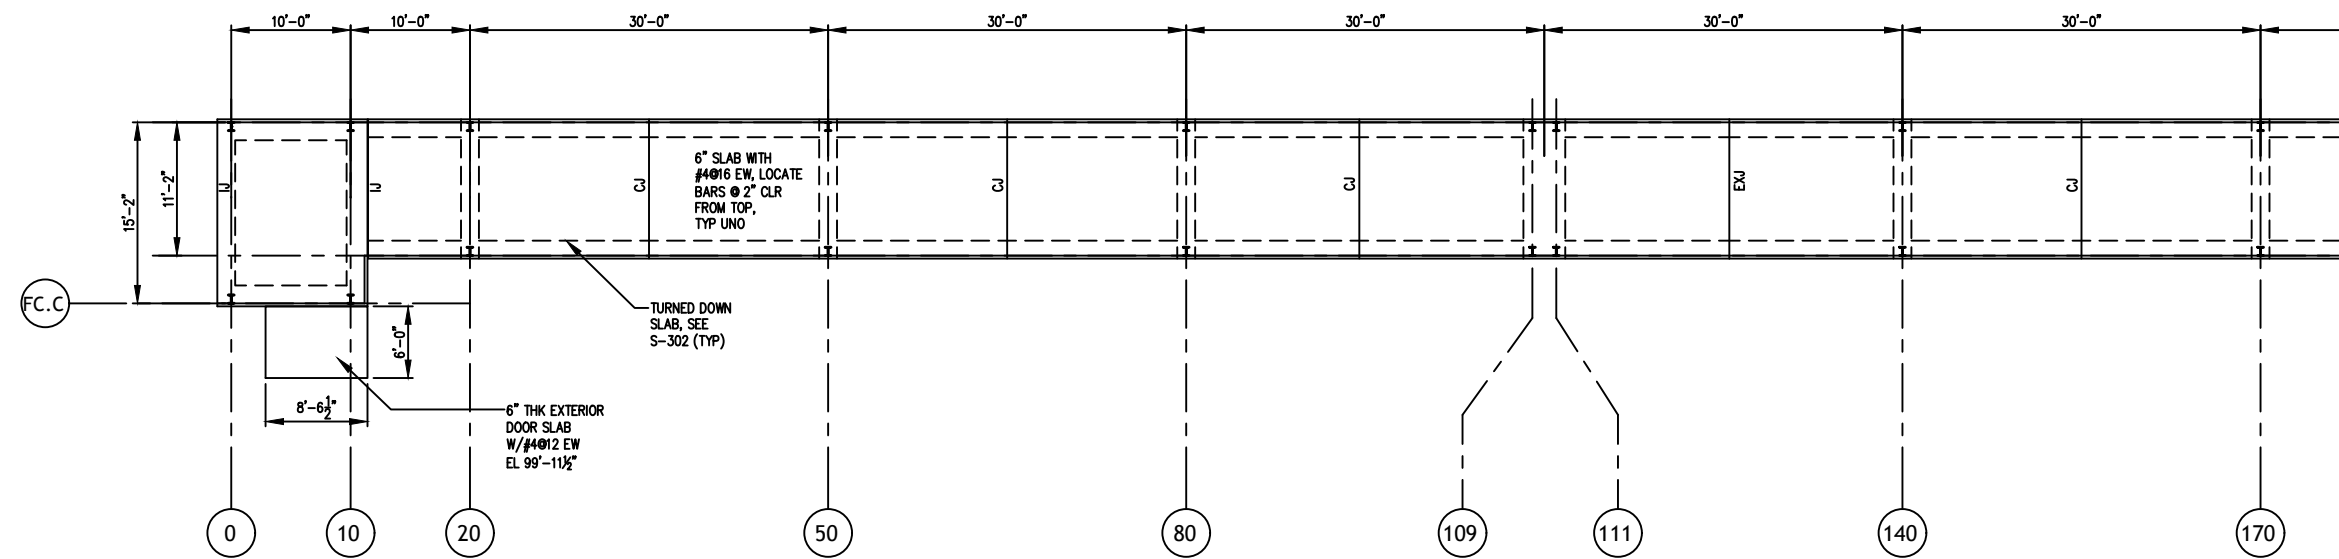

1 FC TUBE ENCLOSURE A - SLAB PLAN
S100 1/8" = 1'-0"

NOTES

- FOR JOINT TYPES SEE S-203
IJ = ISOLATION JOINT
EXJ = EXPANSION JOINT
CJ = CONTROL JOINT
- CONTRACTOR TO PROPOSE CONSTRUCTION JOINT LOCATIONS TO ENGINEER OF RECORD FOR APPROVAL.

LIGO-D2100346-v1

D DANA ENGINEERING, INC.
PROFESSIONAL SERVICE CORPORATION

4000 SOUTH IRBY STREET
KENNEWICK, WA 99337
(509) 582-0126

Revisions		
No.	Description	Date

LIGO Laboratory A+ Project
Hanford, WA

FC TUBE ENCLOSURE A FOUNDATION AND SLAB PLAN

	project number	21262.00	drawing number	S103
	date	01.13.21		
	phase	CONSTRUCTION		